

LEGEND OF SYMBOLS		
SYMBOL	DESCRIPTION	MOUNTING HEIGHT
	FLUORESCENT FIXTURE - ON NORMAL SUPPLY. LETTER DENOTES TYPE.	—
	FLUORESCENT FIXTURE ON NORMAL AND EMERGENCY SUPPLY. LETTER DENOTES TYPE.	—
	INCANDESCENT FIXTURE - CEILING MOUNTED. LETTER DENOTES TYPE.	—
	INCANDESCENT FIXTURE - WALL MOUNTED. LETTER DENOTES TYPE.	—
	EXIT LIGHT - WALL MOUNTED. EXIT LIGHT - CEILING MOUNTED.	—
	INCANDESCENT FIXTURE ON NORMAL AND EMERGENCY SUPPLY. LETTER DENOTES TYPE.	—
	LIGHTING PANEL (LP); RECEPTACLE PANEL (RP); POWER PANEL (PP); DISTRIBUTION PANEL (DP); KITCHEN DISTRIBUTION PANEL (KDP); EMERGENCY SUPPLY PANEL (ESP); COMPUTER PANEL (CP).	8'-0" TO TOP
	DUPLEX RECEPTACLE - FLOOR MOUNTED - 15A, 120V.	—
	FLUSH FLOOR OUTLET WITH SINGLE RECEPTACLE - 15A, 120V.	—
	FLUSH FLOOR OUTLET WITHOUT RECEPTACLE AND COVER - FOR FUTURE.	—
	DUPLEX WALL RECEPTACLE - 15A, 120V.	12" AFF.
	SINGLE WALL RECEPTACLE - 30A, 600V, 3Ø, 4W.	AS SHOWN
	SINGLE WALL RECEPTACLE - 30A, 120V, 3Ø.	AS SHOWN
	SINGLE WALL RECEPTACLE - 15A, 120V, 3Ø.	AS SHOWN
	DUPLEX WALL RECEPTACLE - 15A, 120V, FOR KITCHEN EQUIPMENT.	48" AFF.
	DUPLEX WALL RECEPTACLE - 15A, 120V, FOR KITCHEN UTILITY RECEPTACLE SUPPLIED BY KITCHEN EQUIPMENT SUPPLIER AND INSTALLED BY ELECTRICAL CONTRACTOR.	6" ABOVE SPLASH BACK, 50" AFF.
	S.P.S.T. TOGGLE SWITCH.	4'-6" AFF.
	THREE-WAY TOGGLE SWITCH.	4'-6" AFF.
	DOOR OPERATED SWITCH.	AS SHOWN
	KEY OPERATED SWITCH.	4'-6" AFF.
	LOW VOLTAGE SWITCH.	4'-6" AFF.
	TELEPHONE OUTLET - WALL MOUNTED.	12" AFF.
	PAY TELEPHONE OUTLET - WALL MOUNTED.	4'-6" AFF.
	TELEPHONE OUTLET - FLOOR MOUNTED.	—
	TELEPHONE OUTLET - FLOOR MOUNTED - FOR SMALL CALL DIRECTOR (SAY SET).	—
	TELEPHONE OUTLET - FLOOR MOUNTED - FOR LARGE CALL DIRECTOR.	—
	OUTLET BOX.	—
	BLANK OUTLET BOX.	—
	LOW VOLTAGE RELAY - OUTLET BOX MOUNTED.	—
	PULL BOX.	—
	JUNCTION BOX.	—
	CLOCK - CEILING MOUNTED - LETTER DENOTES TYPE.	1'-0" BELOW RAISED CEILING OR AS NOTED.
	CLOCK - WALL MOUNTED - LETTER DENOTES TYPE.	—
	FIRE ALARM BELL (C - CEILING MOUNTED; A - MOUNTED IN CEILING SPACE; (S) - UNLESS OTHERWISE NOTED).	—
	FIRE ALARM PULL STATION.	4'-6" AFF.
	FIRE ALARM AUTOMATIC DETECTOR. A - 55° RATE OF RISE AND FIXED TEMPERATURE. B - 500°F. FIXED TEMPERATURE.	—
	SMOKE DETECTOR. A - CEILING MOUNTED. B - MOUNTED BELOW RAISED FLOOR. C - SELF-CONTAINED UNIT. D - SURFACE MTD. IN FRONT OF MECH. RETURN AIR DUCT. E - C/N SAMPLING TUBES EXTENDED THROUGH MECH. DUCT.	SEE 10/5/10 SEE 8/5/11 SEE 10/5/11
	SPRINKLER FLOW SWITCH.	—
	FIRE ALARM END OF LINE RESISTOR.	—
	MOTOR - 120V, 1Ø, 50W.	—
	MOTOR - 416V, 3Ø, 60W.	—
	MANUAL STARTER.	4'-6" AFF.
	MAGNETIC STARTER.	—
	DISCONNECT SWITCH. U - UNUSED.	4'-6" AFF.
	COMBINED MAGNETIC STARTER AND DISCONNECT SWITCH.	4'-6" AFF.
	PUSH BUTTON & SPEAKER - DOOR ANSWERING.	—
	PUSH BUTTON STATION. LOS - LOCK - OUT - STOP.	4'-6" AFF.
	THERMOSTAT.	5'-6" AFF.
	CONTRACTOR (SIZE AS REQUIRED).	—
	DIRECT CONNECTION.	—
	HOME RUN TO PANEL UNLESS OTHERWISE NOTED.	—
	CONDUIT IN SLAB OR CEILING SPACE BELOW WITH NUMBER OF WIRES AS SHOWN.	—
	CONDUIT EXPOSED OR IN CEILING SPACE ABOVE WITH NUMBER OF WIRES AS SHOWN.	—
	CONDUIT GOING DOWN.	—
	CONDUIT GOING UP.	—
	UNDERFLOOR & TRENCH DUCT SYSTEM. T - TELEPHONE CELL. P - POWER CELL.	—
	BUS DUCT.	—
	CABLE TRAY.	—
	CONTROL TRANSFORMER.	—

1 LEGEND OF SYMBOLS

	GROUND ROD.	—
	GROUND CONNECTION.	—
	LIGHTNING ARRESTER.	—
	LIGHTNING ROD.	—
	LOCAL DIMMER FOR INCANDESCENT LIGHTS.	4'-6" AFF.
	REMOTE CONTROL STATION FOR INCANDESCENT DIMMING SYSTEM.	4'-6" AFF.
	FLUORESCENT DIMMING INTENSITY SELECTOR CONTROL.	4'-6" AFF.
	WEATHER PROBE.	—
	TWIST LOCK.	—
	PILOT LIGHT.	—
	KITCHEN EQUIPMENT ITEM NO. 9.	—
	DETAIL NO. 6 ON SAME DRAWING.	—
	DETAIL NO. 7 ON DRAWING NO. 50B.	—
	DETAIL NO. 4 ON DRAWING NO. 511.	—
	ROOM NO. 127. SEE ARCHITECTURAL ROOM SCHEDULE FOR ROOM NAMES.	—


1 CONT'D

DRAWING	TITLE
69039-501	PLOT PLAN AND LEGENDS
69039-502	MAIN ONE LINE DIAGRAM
69039-503	PARKING LEVEL E - LIGHTING AND POWER
69039-504	PARKING LEVEL C & D - LIGHTING AND POWER
69039-505	PARKING LEVEL A & B - LIGHTING AND POWER
69039-506	GROUND FLOOR PLAN - LIGHTING
69039-507	GROUND FLOOR PLAN - POWER
69039-508	2 ND FLOOR PLAN - LIGHTING
69039-509	2 ND FLOOR PLAN - POWER
69039-510	5 TH FLOOR PLAN - LIGHTING
69039-511	TYPICAL FLOOR PLAN - 3 RD , 4 TH , 6 TH TO 14 TH - LIGHTING

3 LIST OF ELECTRICAL DRAWINGS

69039-512	TYPICAL FLOOR PLAN - 3 RD TO 14 TH - POWER
69039-513	MECHANICAL FLOOR PLAN - LIGHTING
69039-514	MECHANICAL FLOOR PLAN - POWER
69039-515	TELEPHONE AND ELECTRICAL ROOMS DETAILS
69039-516	ROOF PLANS AND DETAILS
69039-517	PANEL SCHEDULE & DISTRIBUTION PANELS DETAILS
69039-518	MCC'S AND SCHEMATICS
69039-519	MISC. RISERS AND DETAILS
69039-520	DETAILS

3 CONT'D

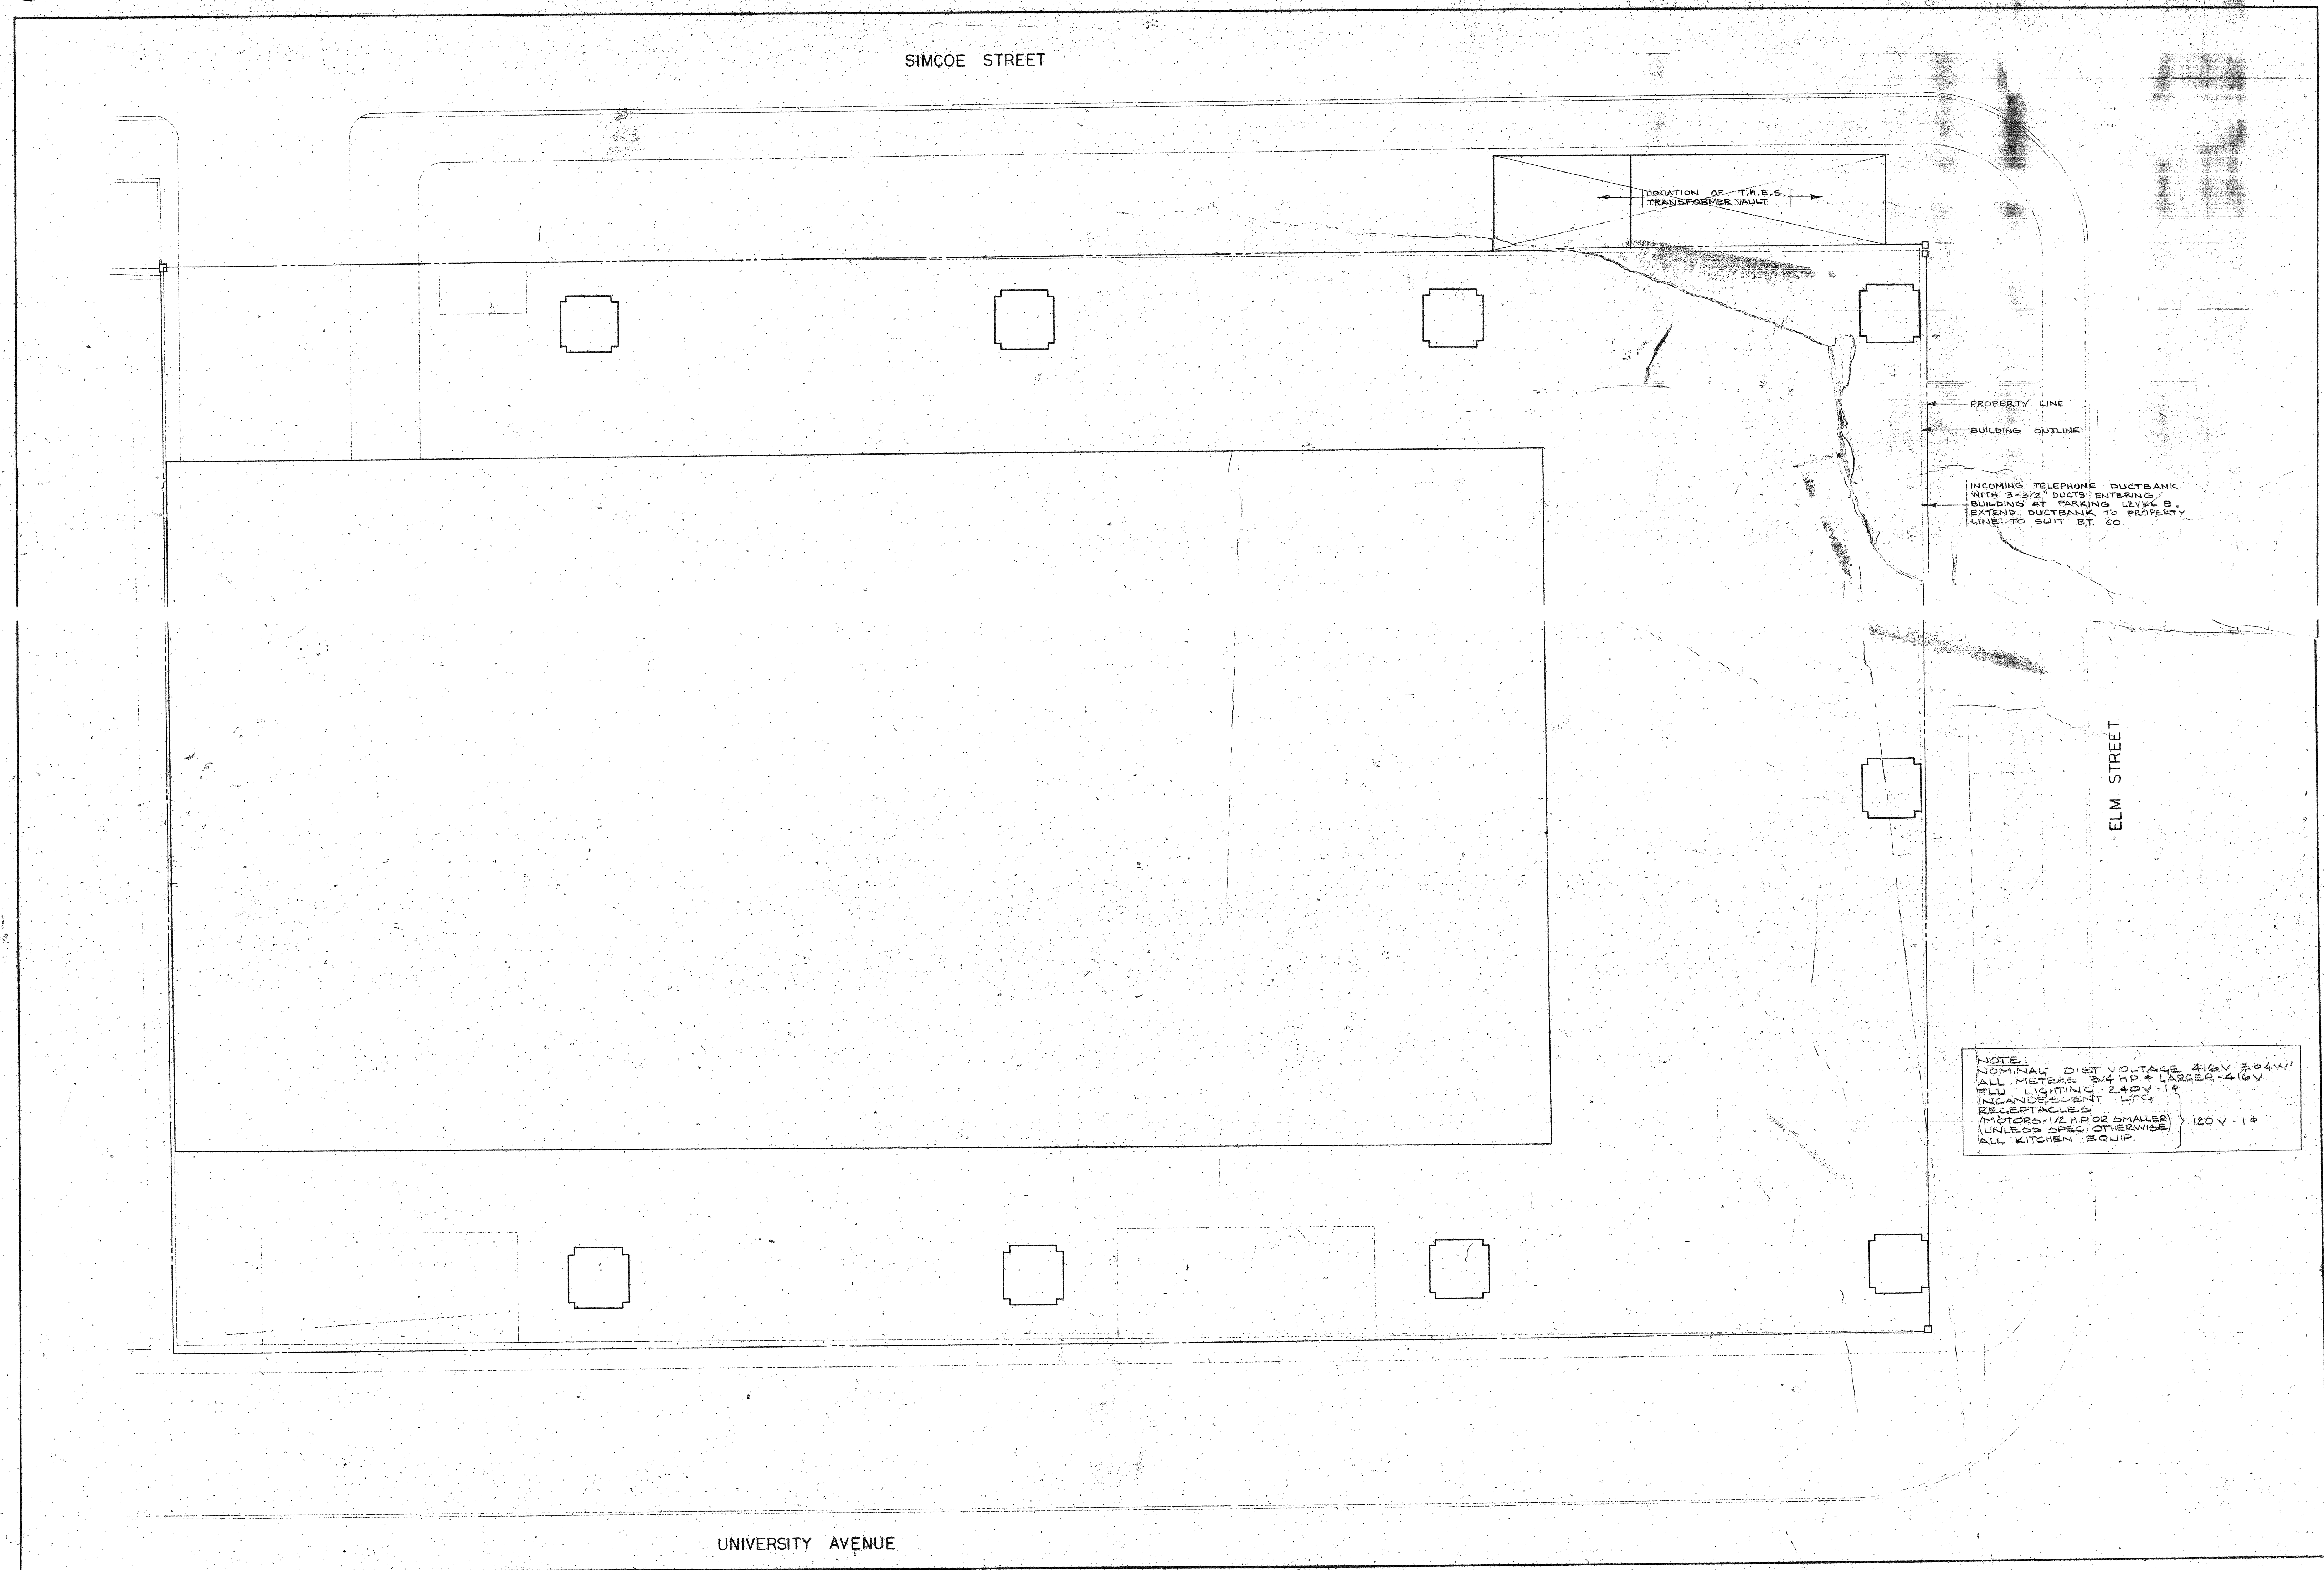

2 PLOT PLAN SCALE: 1/8" = 1'-0"

No.	Rev.	Description	Date	By
1	1	Rev. for CON.		
2	2	Rev. for ARCHITECTURAL		
3	3	Rev. for ELECTRICAL		
4	4	Rev. for MECHANICAL		
5	5	Rev. for CIVIL		
6	6	Rev. for LANDSCAPE		
7	7	Rev. for STRUCTURAL		
8	8	Rev. for SANITARY		
9	9	Rev. for ELECTRICAL		
10	10	Rev. for MECHANICAL		
11	11	Rev. for CIVIL		
12	12	Rev. for LANDSCAPE		
13	13	Rev. for STRUCTURAL		
14	14	Rev. for SANITARY		
15	15	Rev. for ELECTRICAL		
16	16	Rev. for MECHANICAL		
17	17	Rev. for CIVIL		
18	18	Rev. for LANDSCAPE		
19	19	Rev. for STRUCTURAL		
20	20	Rev. for SANITARY		
21	21	Rev. for ELECTRICAL		
22	22	Rev. for MECHANICAL		
23	23	Rev. for CIVIL		
24	24	Rev. for LANDSCAPE		
25	25	Rev. for STRUCTURAL		
26	26	Rev. for SANITARY		
27	27	Rev. for ELECTRICAL		
28	28	Rev. for MECHANICAL		
29	29	Rev. for CIVIL		
30	30	Rev. for LANDSCAPE		
31	31	Rev. for STRUCTURAL		
32	32	Rev. for SANITARY		
33	33	Rev. for ELECTRICAL		
34	34	Rev. for MECHANICAL		
35	35	Rev. for CIVIL		
36	36	Rev. for LANDSCAPE		
37	37	Rev. for STRUCTURAL		
38	38	Rev. for SANITARY		
39	39	Rev. for ELECTRICAL		
40	40	Rev. for MECHANICAL		
41	41	Rev. for CIVIL		
42	42	Rev. for LANDSCAPE		
43	43	Rev. for STRUCTURAL		
44	44	Rev. for SANITARY		
45	45	Rev. for ELECTRICAL		
46	46	Rev. for MECHANICAL		
47	47	Rev. for CIVIL		
48	48	Rev. for LANDSCAPE		
49	49	Rev. for STRUCTURAL		
50	50	Rev. for SANITARY		
51	51	Rev. for ELECTRICAL		
52	52	Rev. for MECHANICAL		
53	53	Rev. for CIVIL		
54	54	Rev. for LANDSCAPE		
55	55	Rev. for STRUCTURAL		
56	56	Rev. for SANITARY		
57	57	Rev. for ELECTRICAL		
58	58	Rev. for MECHANICAL		
59	59	Rev. for CIVIL		
60	60	Rev. for LANDSCAPE		
61	61	Rev. for STRUCTURAL		
62	62	Rev. for SANITARY		
63	63	Rev. for ELECTRICAL		
64	64	Rev. for MECHANICAL		
65	65	Rev. for CIVIL		
66	66	Rev. for LANDSCAPE		
67	67	Rev. for STRUCTURAL		
68	68	Rev. for SANITARY		
69	69	Rev. for ELECTRICAL		
70	70	Rev. for MECHANICAL		
71	71	Rev. for CIVIL		
72	72	Rev. for LANDSCAPE		
73	73	Rev. for STRUCTURAL		
74	74	Rev. for SANITARY		
75	75	Rev. for ELECTRICAL		
76	76	Rev. for MECHANICAL		
77	77	Rev. for CIVIL		
78	78	Rev. for LANDSCAPE		
79	79	Rev. for STRUCTURAL		
80	80	Rev. for SANITARY		
81	81	Rev. for ELECTRICAL		
82	82	Rev. for MECHANICAL		
83	83	Rev. for CIVIL		
84	84	Rev. for LANDSCAPE		
85	85	Rev. for STRUCTURAL		
86	86	Rev. for SANITARY		
87	87	Rev. for ELECTRICAL		
88	88	Rev. for MECHANICAL		
89	89	Rev. for CIVIL		
90	90	Rev. for LANDSCAPE		
91	91	Rev. for STRUCTURAL		
92	92	Rev. for SANITARY		
93	93	Rev. for ELECTRICAL		
94	94	Rev. for MECHANICAL		
95	95	Rev. for CIVIL		
96	96	Rev. for LANDSCAPE		
97	97	Rev. for STRUCTURAL		
98	98	Rev. for SANITARY		
99	99	Rev. for ELECTRICAL		
100	100	Rev. for MECHANICAL		

Revisions

Drawn: C. B.

Date: 5 FEB. 1971

Checked: C.A.

Pre-Design: J.W.

Design: J.W.

Architectural: J.W.

Structural: J.W.

Heating: J.W.

Sanitary: J.W.

Electrical: J.W.

Specifications: J.W.

Process: J.W.

Printed: JAN 15 1981

All prints and specifications are the property of the architect and must be returned at the completion of the work.

This drawing not to be used for construction purposes until countersigned by:

Date: 21 MAY 71

NATIONAL LIFE OF CANADA

Head Office Building University Avenue, Toronto, Canada

Searle Wilbee Rowland

Architect-Engineer-Plan