




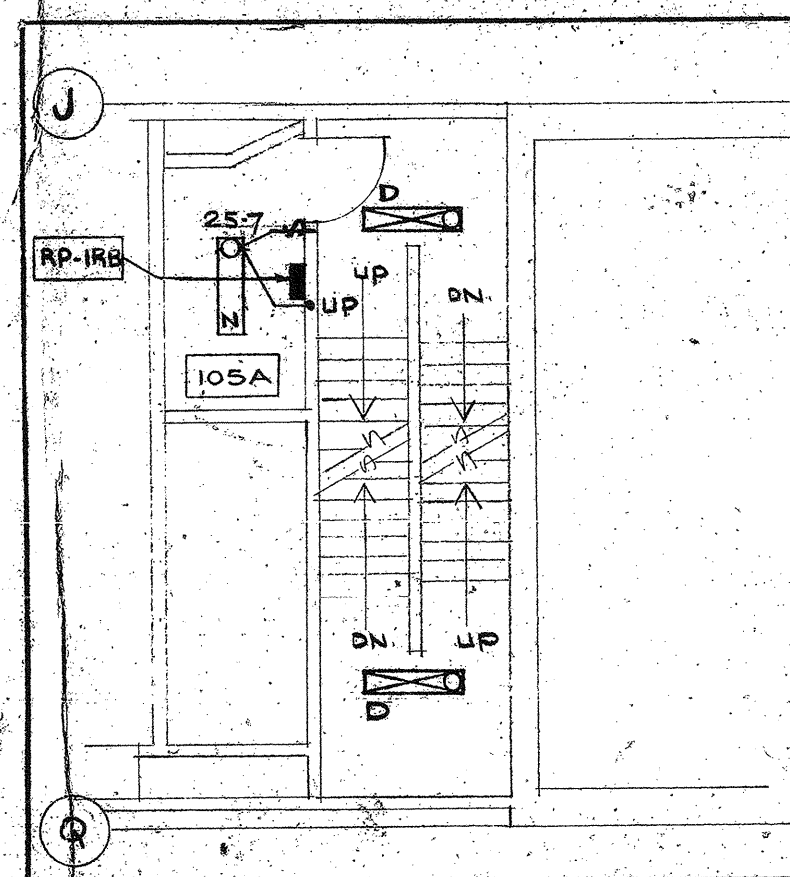


1 STAIR SI&S2 LIGHTING AT INTERMEDIATE LANDING BETWEEN GROUND & 2ND FLOOR. SCALE 1/8"=1'-0"

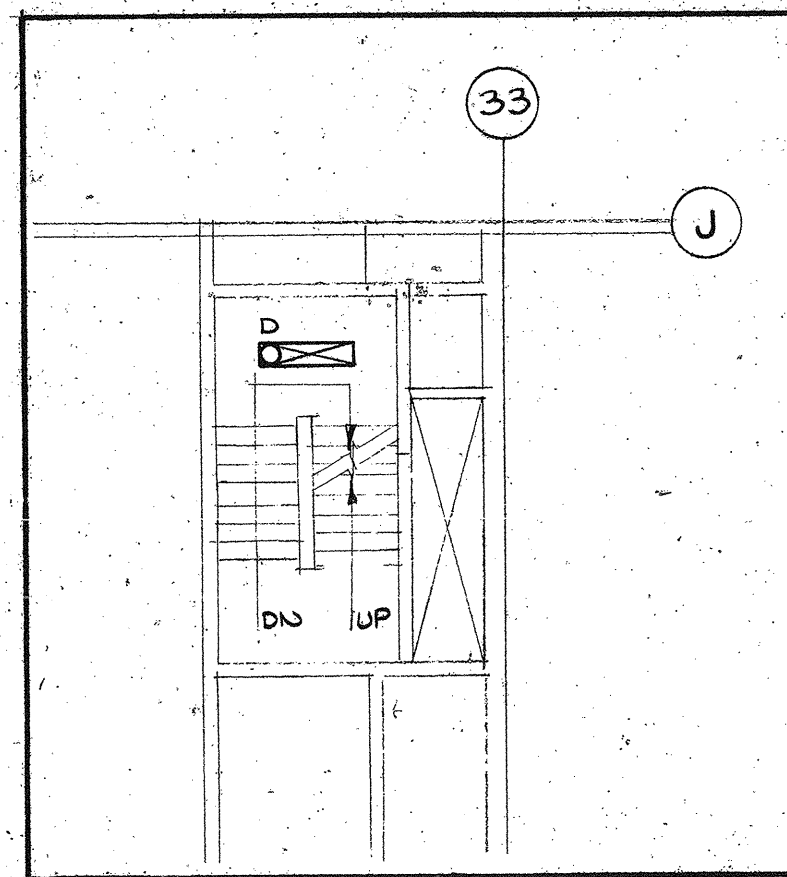


2 STAIR S5 LIGHTING AT INTERMEDIATE LANDING BETWEEN GROUND & 2ND FLOOR. SCALE 1/8"=1'-0"

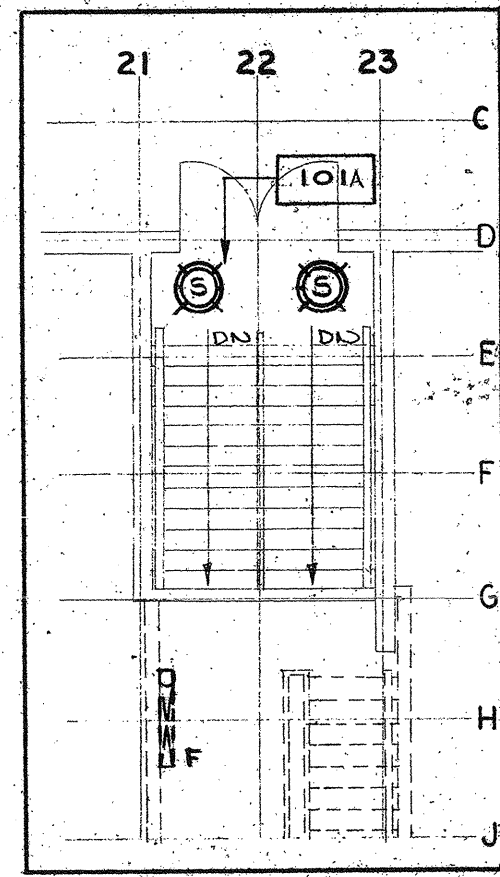

3 STAIR S1 LIGHTING AT INTERMEDIATE LANDING BETWEEN GROUND & 2ND FLOOR. SCALE 1/8"=1'-0"

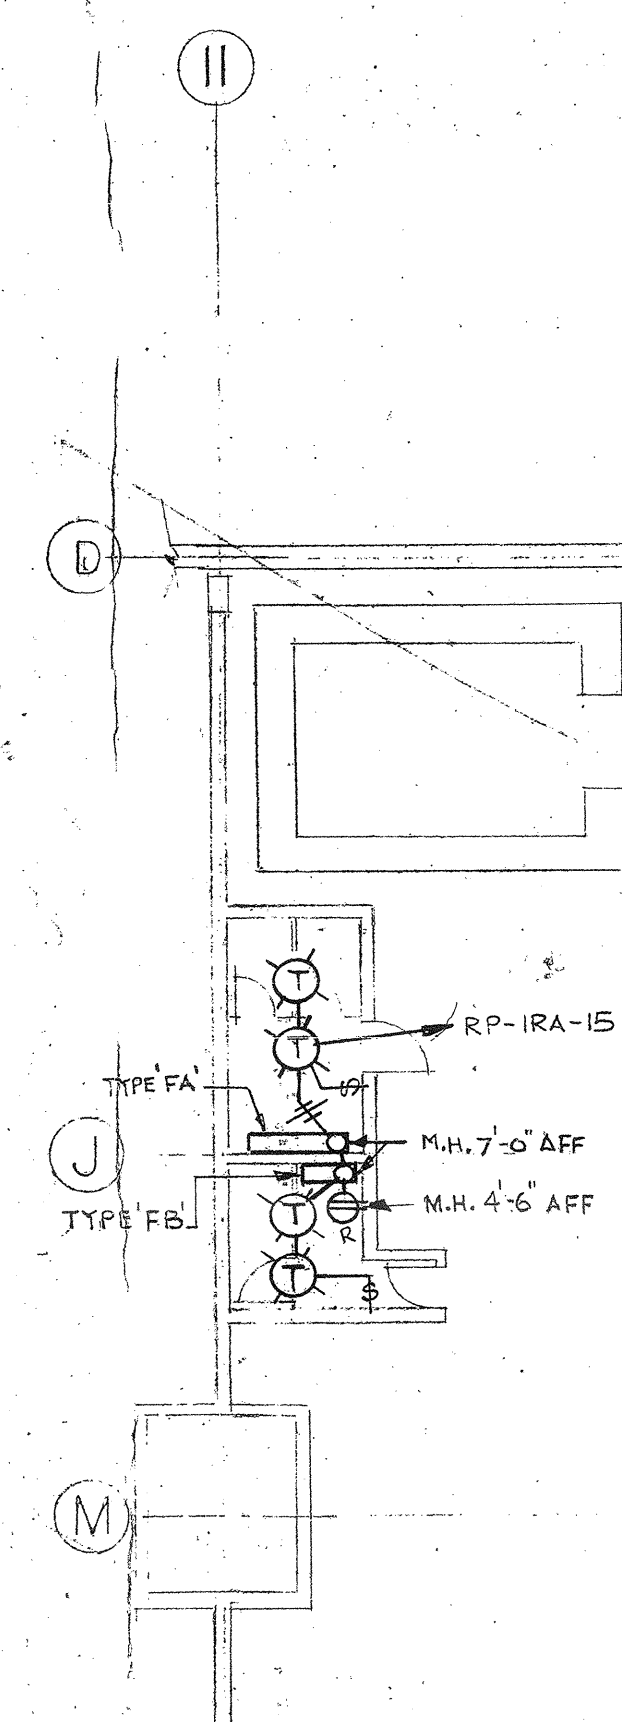

4 PART PLAN AT LOW CEILING IN BANK WASHROOMS. SCALE: 1/8"=1'-0"

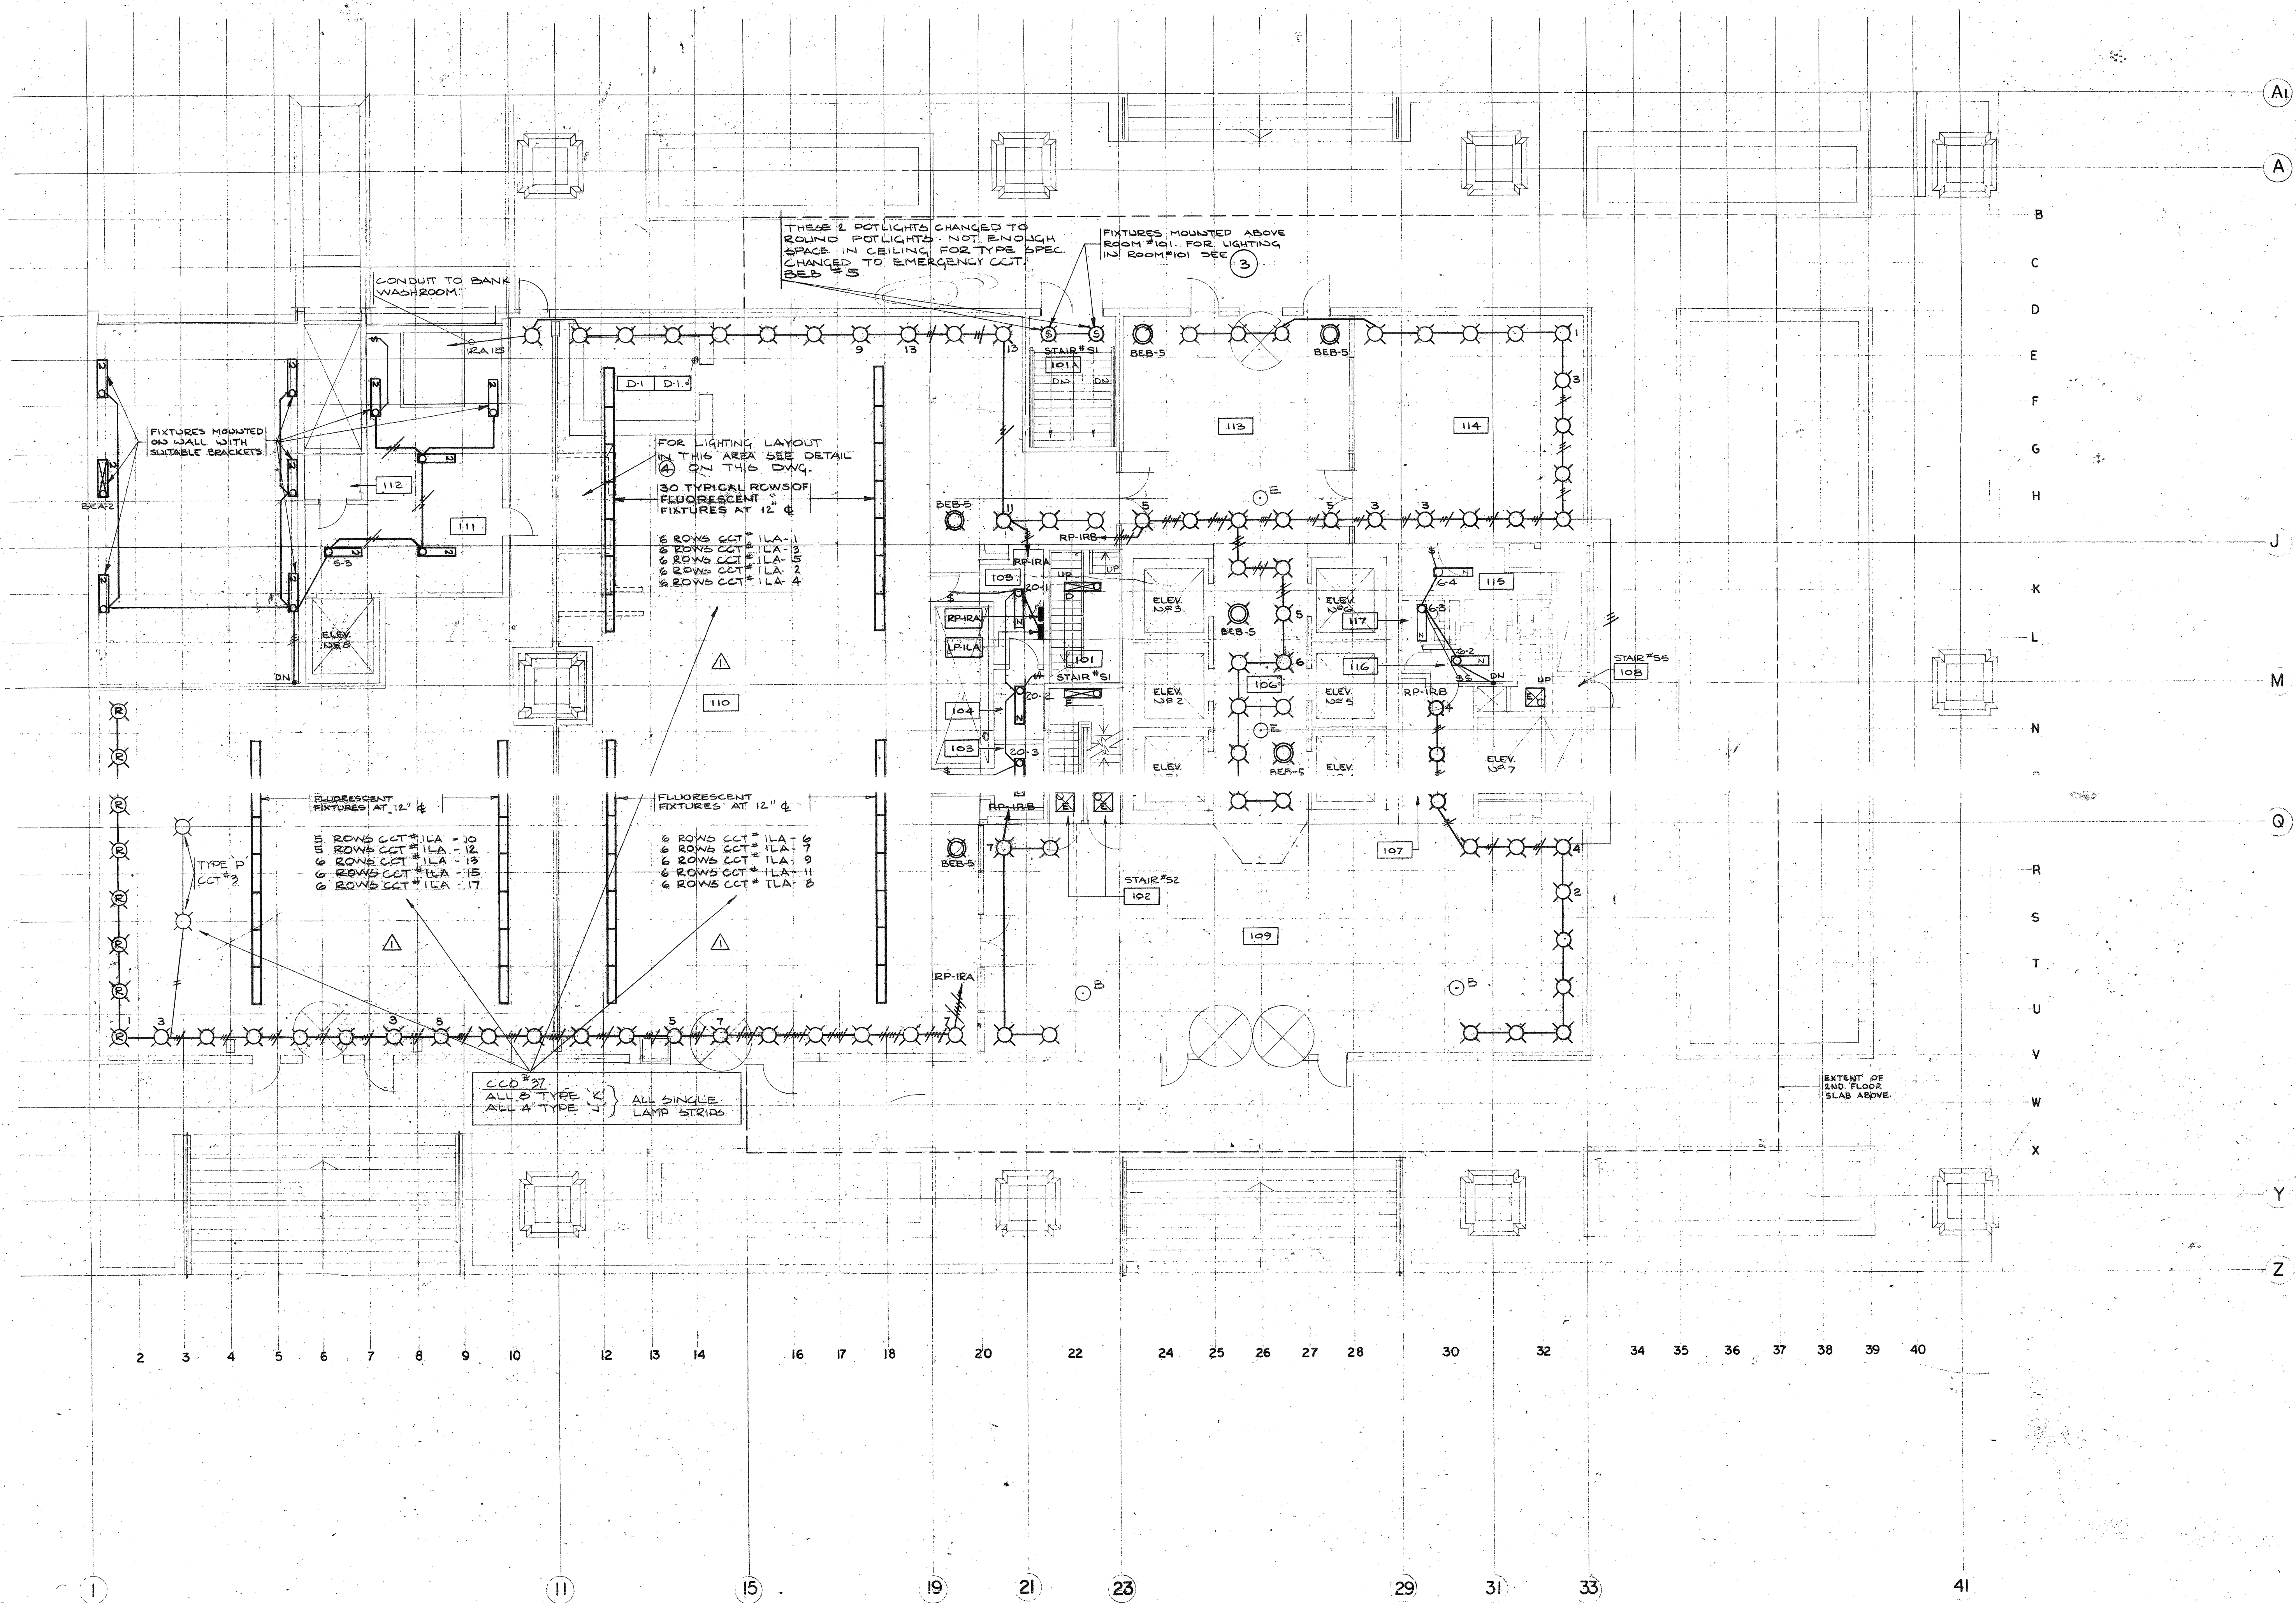

THE LOCATION OF EQUIPMENT SUCH AS LIGHTING FIXTURES, SPRINKLER HEADS, AIR DIFFUSERS, IS SHOWN IN DIAGRAMATIC FORM. THE EXACT LOCATION OF ALL SUCH EQUIPMENT SHALL BE CO-ORDINATED BY THE CONTRACTOR TO CONFORM TO THE OVERALL CEILING PATTERN. THE CONTRACTOR SHALL ENSURE THAT THE LOCATIONS ARE APPROVED BY THE ARCHITECT BEFORE THE EQUIPMENT IS INSTALLED. THE LOCATION OF EQUIPMENT SUCH AS SWITCHES, THERMOSTATS, AND CONTROLS IS SHOWN IN DIAGRAMATIC FORM. THE CONTRACTOR SHALL CO-ORDINATE THE EXACT LOCATION, KEEPING ALL SUCH EQUIPMENT AS CLOSE TO DOOR JAMBS AND OTHER OBSTACLES AS POSSIBLE WHEN MOUNTED TO WALLS OR STEEL COLUMNS. ALL SUCH EQUIPMENT SHALL BE MOUNTED ON THE WEBS OF THE COLUMNS UNLESS NOTED OTHERWISE. THE CONTRACTOR SHALL ENSURE THAT THE LOCATIONS ARE APPROVED BY THE ARCHITECT BEFORE THE EQUIPMENT IS INSTALLED. ALL METAL PARTS OF EQUIPMENT EXPOSED ON THE EXTERIOR OF THE BUILDING SHALL BE CO-ORDINATED BY THE CONTRACTOR TO PRESERVE A UNIFORM COLOUR THROUGHOUT.

NOTE:
1. ALL INCANDESCENT FIXTURES ON THIS DRAWING SHALL BE TYPE "P" UNLESS OTHERWISE NOTED

No.	Ref.	Description	Date
1		REVISED FOR C.C.P. 2	
2		REVISED FOR C.C.P. 2	
3		REVISED FOR C.C.P. 2	
4		REVISED FOR C.C.P. 2	
5		REVISED FOR C.C.P. 2	

Revisions	
Drawn	CM
Date	5 FEB 1971
Checked	C.A.
Pre-Design	
Design	P.W.
Architectural	JAR
Structural	BU
Heating	AJ
Sanitary	AL
Electrical	CA
Specifications	RS
Process	
Printed	
Date	JAN 15 1971

All work must be checked on the work by the contractor. All plans and specifications are the property of the architect and must be returned at the completion of the work. This drawing is not to be used for construction purposes until countersigned by the architect.

Date 21 May 71

NATIONAL LIFE OF CANADA

Head Office Building
University Avenue, Toronto, Canada

This drawing is the property of
Neil Owen Rowland & Ray

Searle Wilbee Rowland
Architects
Engineers
Planners
Toronto
Canada

ELECTRICAL
GROUND FLOOR PLAN
LIGHTING
Sheet Title
Drawing G
Scale 1/8"=1'-0"
Sheet Number 69039-506