
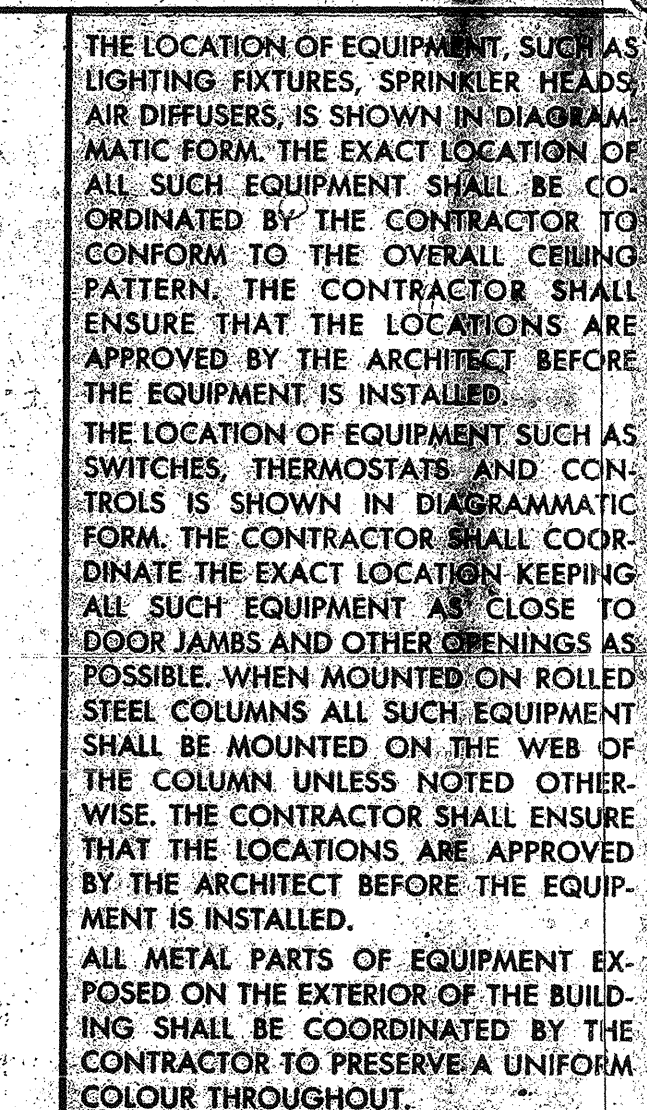


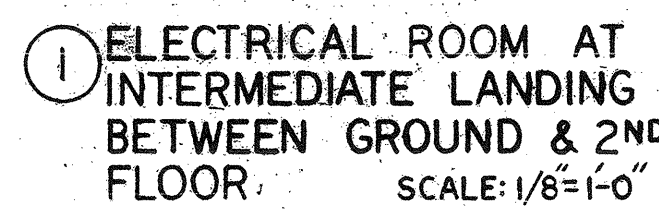

1. ALL WIRING AND CONTROLS FROM LOAD SIDE OF DISCONNECT SWITCHES FOR OVERHEAD DOORS SHALL BE MANIPULATED BY THE SPECIALTIES DIVISION.
2. FOR EQUIPMENT LAYOUT DETAILS OF ROOMS # 104, #105 & #106 REFER TO DWG 9009-315.
3. FOR DETAILS OF S3000 MELTING SYSTEM REFER TO DRAWING 9009-520.
4. PROVIDE 6" DIA. CEILING LIGHTS FROM JUNCTION BOX TO LIGHTS CENTERED TO DWG#6039-21, DETAIL #1.
5. PROVIDE 5" DIA. TWL 3/4" IN BASEMENT CEILING SPACE PER SECTION 05-20.1 THROUGH FLOOR AND UP DOWR MULLION TO DOOR STEPS. SEE DWG# 6039-21, DETAIL #1.
6. PROVIDE ADDITIONAL DUCTS FROM JUNCTION BOX TO DARK AREA ON LINE C-15 ONE FOR ROOFER & ONE

11	AS BUILT	AUG 1974	LK
10	REV FOR CCO #87	AUG 1974	LK
9	REV FOR CCO #84	AUG 1974	LK
8	REV FOR CCO #80	AUG 1974	LK
7	REV FOR CCO #39	AUG 1974	LK

5	▲	REV. FOR C.C.O. #35	17172	C.D.
5	▲	REV. FOR C.C.O. #22	2411472	CA
4	▲	REV. FOR C.C.O. #4	203347	CA
3		REV. FOR CONSTRUCTION	21MAY-71	CA
2		REV. FOR BUREAU NO. 1	21MAY-71	CA
1		REV. FOR BUREAU NO. 2, 3	21MAY-71	CA

Revisions	
Drawn GM	
Date 2 FEB 1971	
Checked C.A. 	
Pre-Design	
Design P.VJ	
Architectural JAS	
Structural BU	
Heating AL	
Sanitary CA	
Electrical CA	
Specifications RK	
Process	
Drawn by:  E.E. 180	

All measurements must be checked on the work by the contractor.

All prints and specifications are the property of the architects and must be returned at the completion of the work.

This drawing not to be used for construction purposes until countersigned by:

Date _____

--	--

NATIONAL LIFE
OF CANADA

Head Office Building
University Avenue, Toronto, Canada

**Searle
Wilbee
Bowland** Architects
Engineers
Planners
Trusted
Counsel

This drawing is the property of
Neish Owen Rowland & Roy

ELECTRICAL
GROUND FLOOR PLAN
Sheet
POWER

Scales	1/8" = 1'-0"
Sheet Number	69039-507