




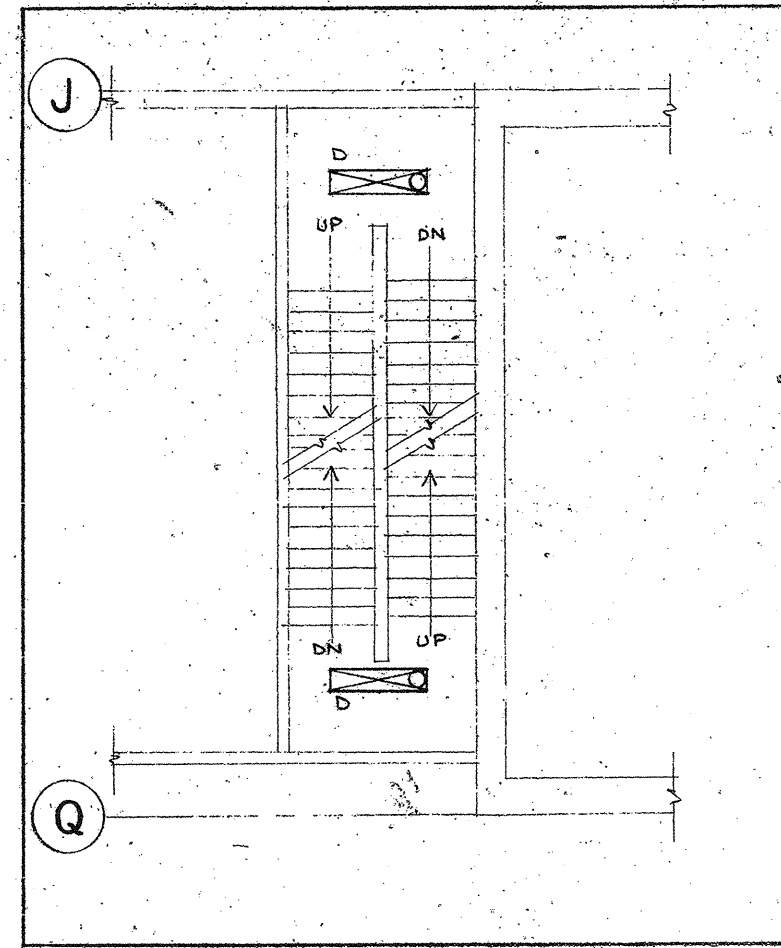

1 STAIR S1 & S2 LIGHTING
INTERMEDIATE LANDING
BETWEEN 2ND & 3RD FLOOR
SCALE: 1/8" = 1'-0"

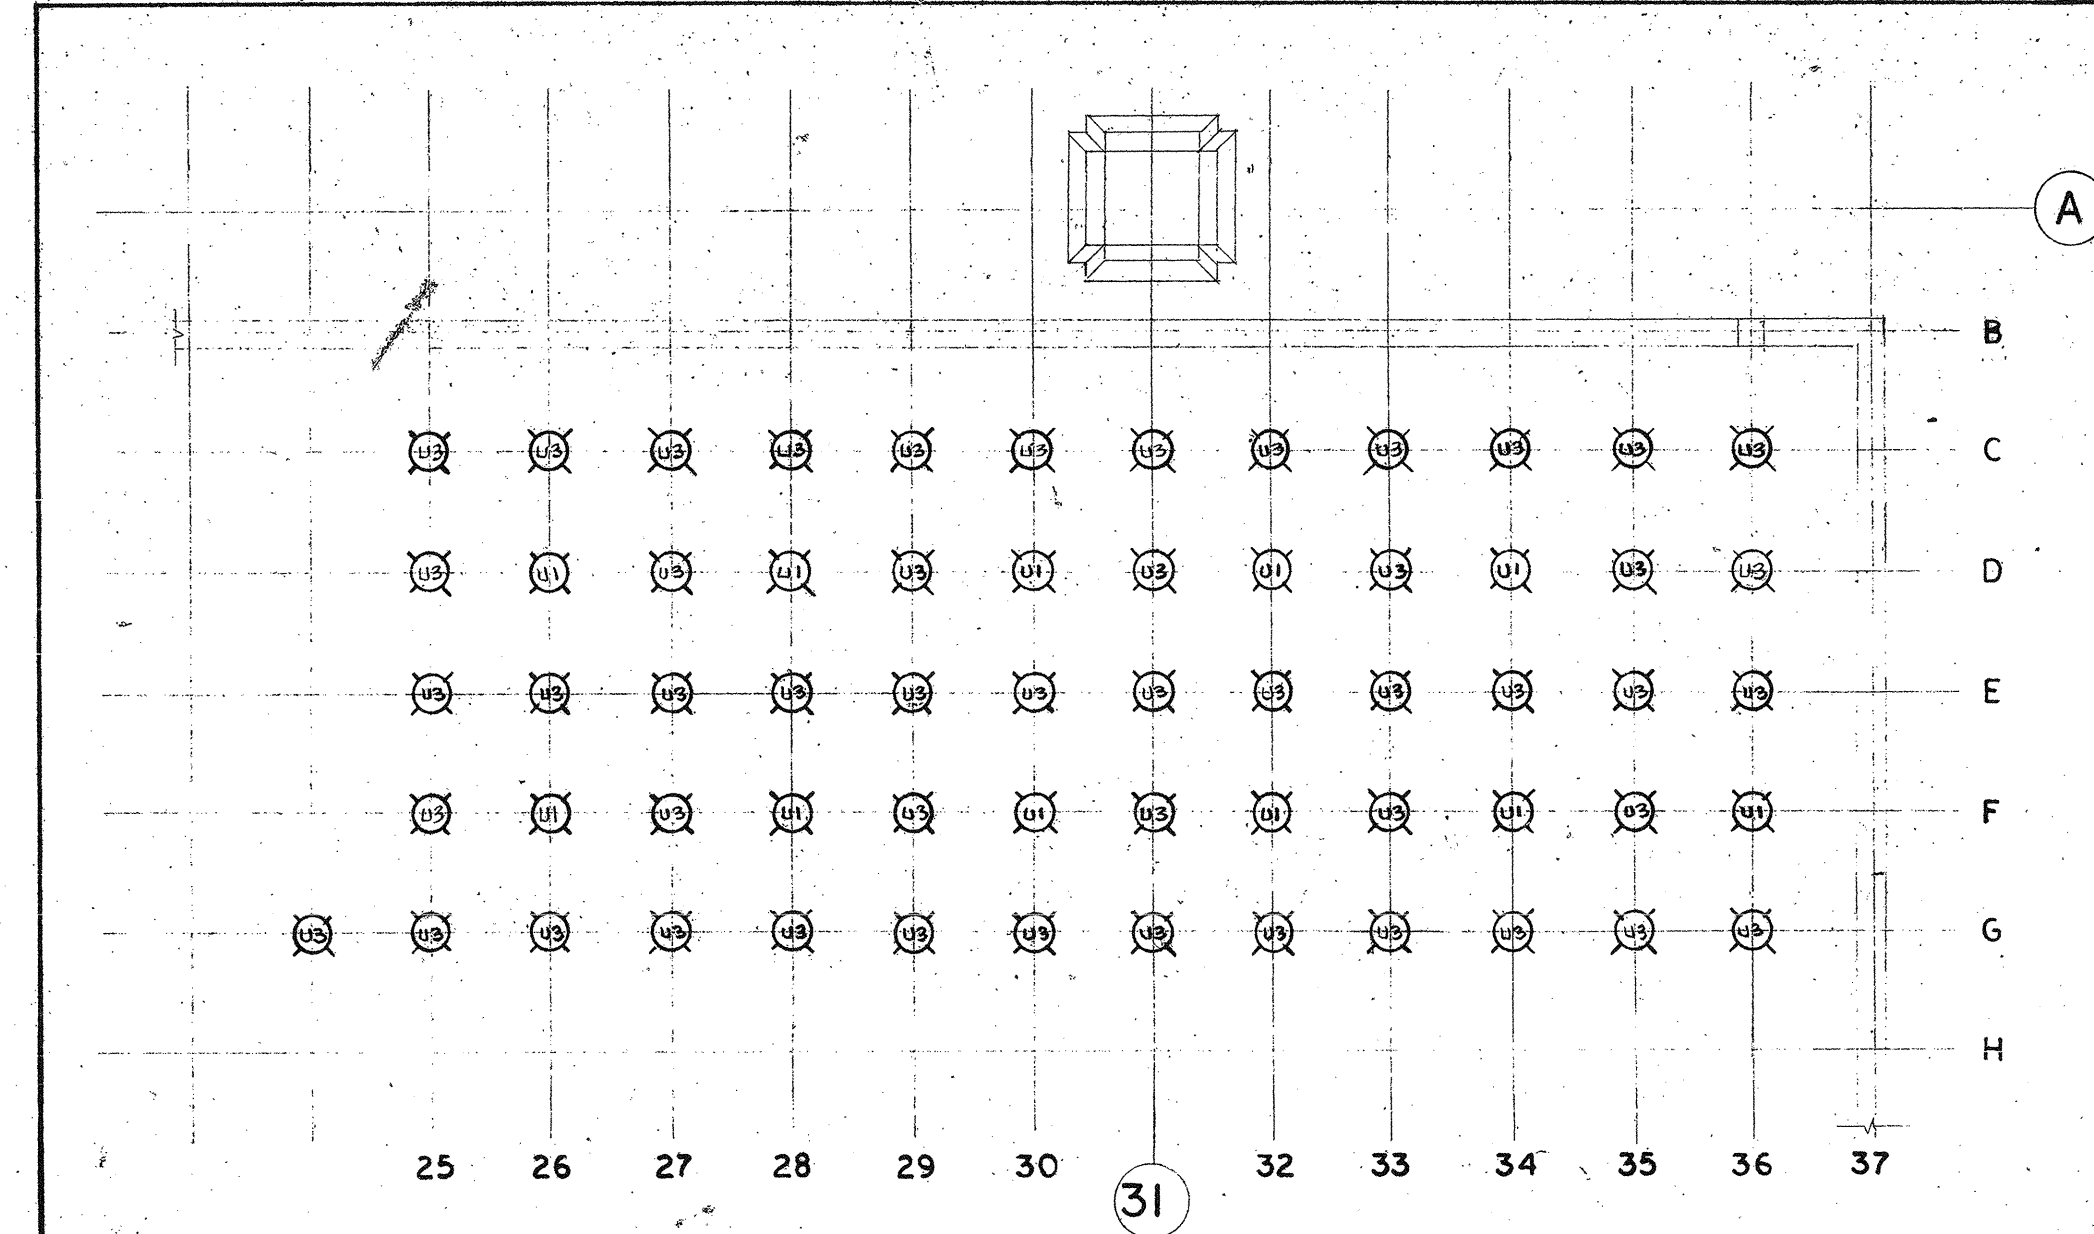

2 PART PLAN SECOND FLOOR LIGHTING
SCALE: 1/8" = 1'-0"

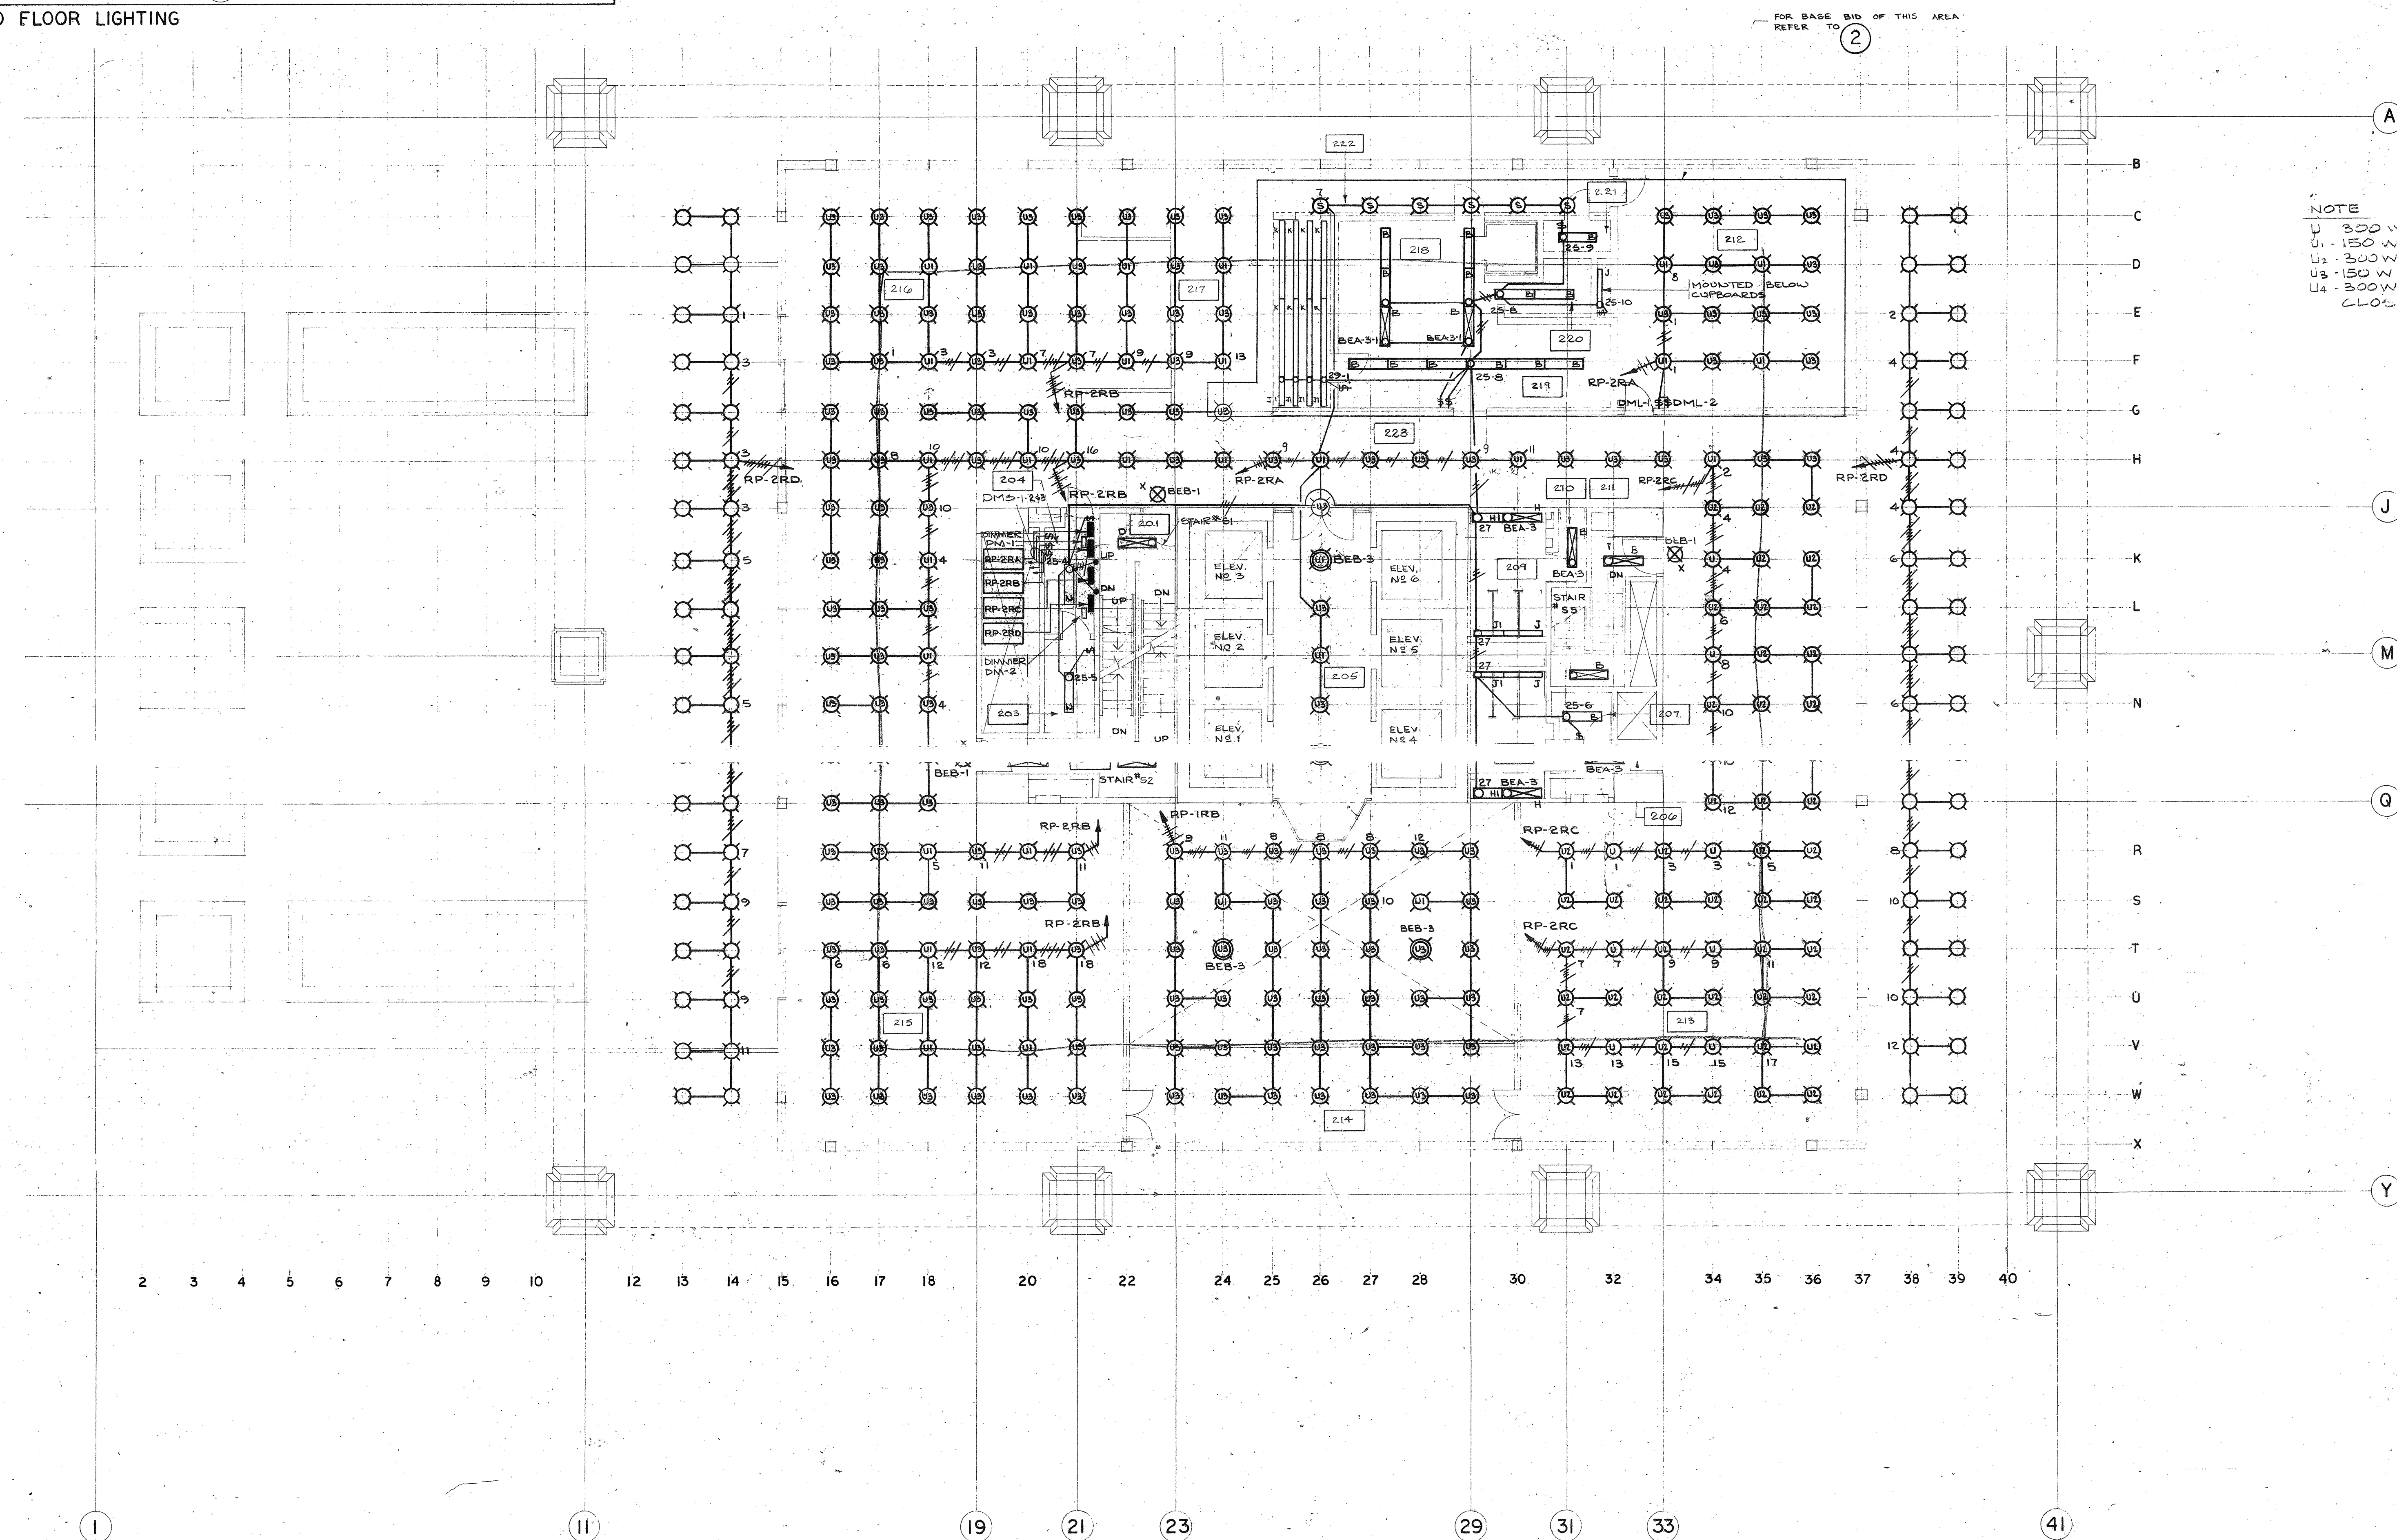

THE LOCATION OF EQUIPMENT, SUCH AS LIGHTING FIXTURES, SWITCHES, THERMOSTATS, AND CONTROLS IS SHOWN IN DIAGRAMATIC FORM. THE CONTRACTOR SHALL COORDINATE THE EXACT LOCATION, KEEPING ALL SUCH EQUIPMENT AS CLOSE TO ROOF JAMBS AND OTHER OPENINGS AS POSSIBLE, WHEN MOUNTED ON ROLLED STEEL COLUMNS ALL SUCH EQUIPMENT SHALL BE MOUNTED ON THE WEB OF THE COLUMN UNLESS NOTED OTHERWISE. THE CONTRACTOR SHALL ENSURE THAT THE LOCATIONS ARE APPROVED BY THE ARCHITECT BEFORE THE EQUIPMENT IS INSTALLED.

ALL METAL PARTS OF EQUIPMENT EXPOSED ON THE EXTERIOR OF THE BUILDING SHALL BE COORDINATED BY THE CONTRACTOR TO PRESERVE A UNIFORM COLOUR THROUGHOUT.

NOTE: ALL INCANDESCENT FIXTURES ON THIS DRAWING SHALL BE TYPE U4 UNLESS OTHERWISE NOTED.

Rev.	Description	Date	By	Check
1	Revise Section 2.4	1/15/71	CA	CA
2	Revise Section 2.4	1/15/71	CA	CA
3	Revise Section 2.4	1/15/71	CA	CA
4	Revise Section 2.4	1/15/71	CA	CA
5	Revise Section 2.4	1/15/71	CA	CA

All measurements must be checked on the work by the contractor.

All prints and specifications are the property of the architects and must be returned at the completion of the work.

This drawing not to be used for construction purposes until countersigned by:

Date: 1/15/71

NATIONAL LIFE OF CANADA

Head Office Building
University Avenue, Toronto, Canada

This drawing is the property of:
Nash Owen Rowland & Roy

Searle Wilbee Rowland
Architects
Engineers
Planners
Toronto
Canada

ELECTRICAL
2ND FLOOR PLAN
LIGHTING

Sheet Title
Scale: 1/8" = 1'-0"
Sheet Number: 69039-508