


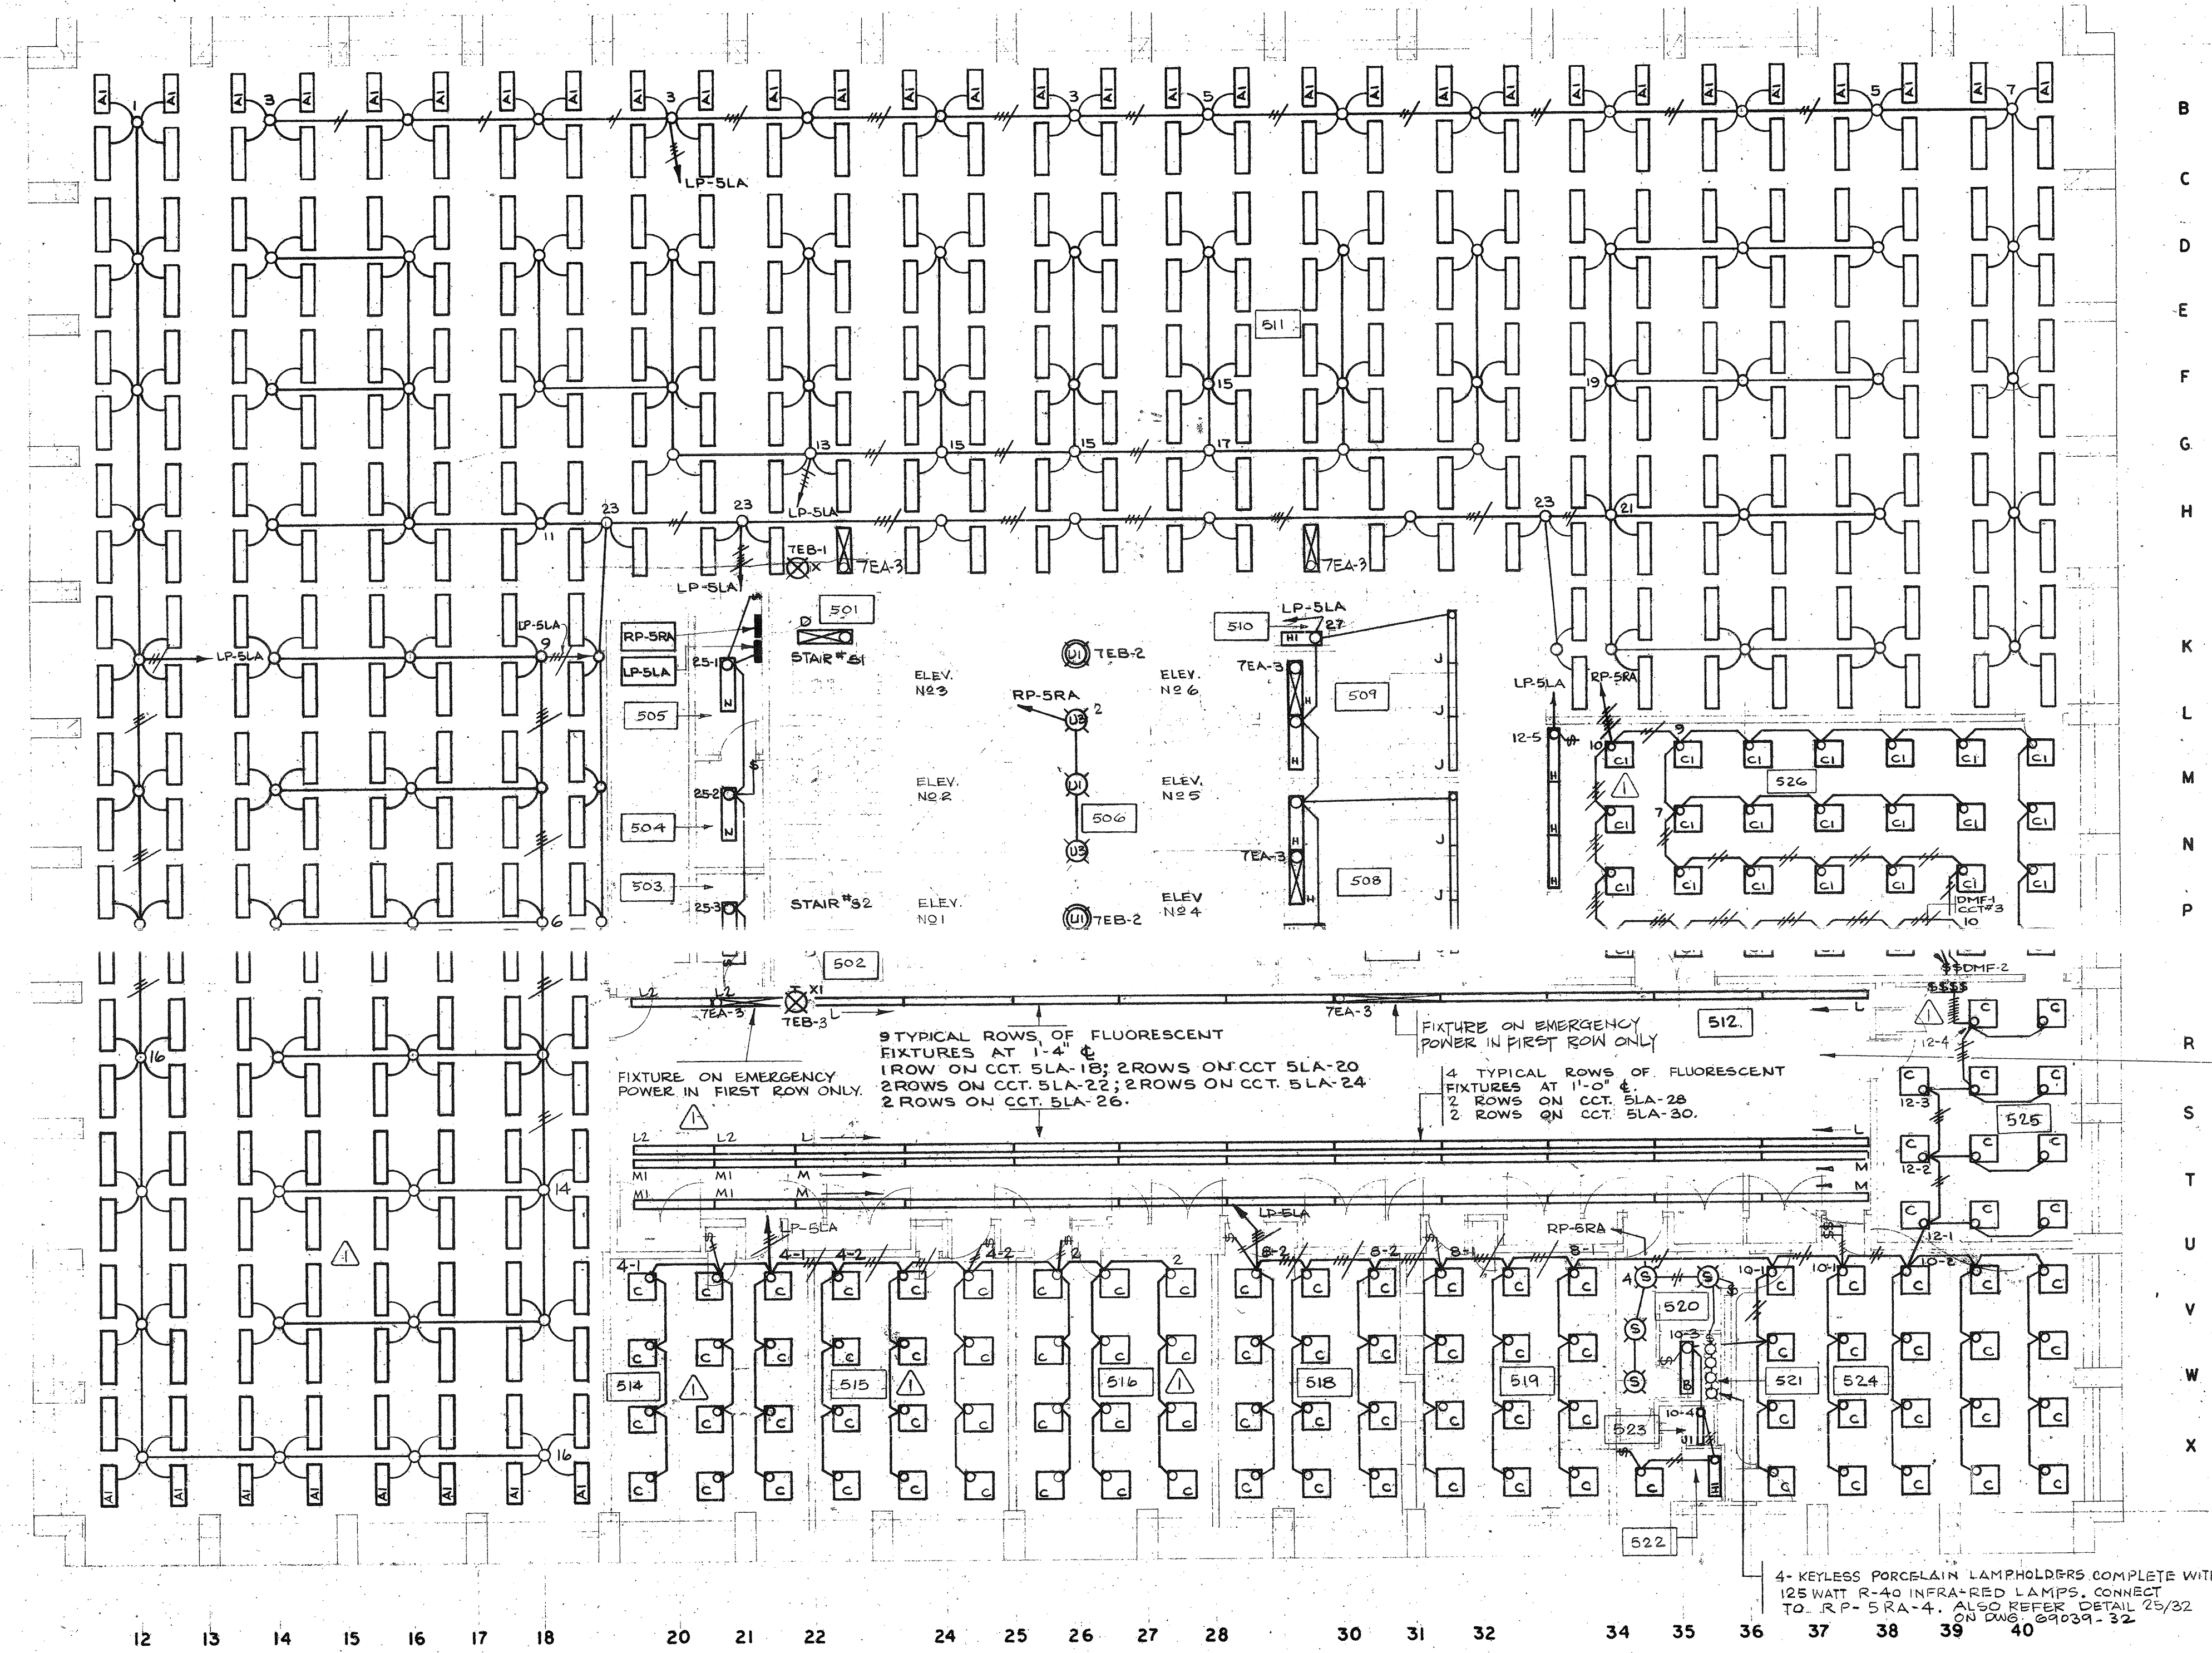

LIGHTING IN THIS AREA DOES NOT FOLLOW ANY SET PATTERN BECAUSE OF DUCT INTERFERENCE HOWEVER CCTS STAY THE SAME.

THE LOCATION OF EQUIPMENT, SUCH AS LIGHTING FIXTURES, SPRINKLER HEADS, AIR DIFFUSERS, IS SHOWN IN DIAGRAMMATIC FORM. THE EXACT LOCATION OF ALL SUCH EQUIPMENT SHALL BE CO-ORDINATED BY THE CONTRACTOR TO CONFORM TO THE OVERALL CEILING PATTERN. THE CONTRACTOR SHALL ENSURE THAT THE LOCATIONS ARE APPROVED BY THE ARCHITECT BEFORE THE EQUIPMENT IS INSTALLED.

THE LOCATION OF EQUIPMENT SUCH AS SWITCHES, THERMOSTATS AND CONTROLS IS SHOWN IN DIAGRAMMATIC FORM. THE CONTRACTOR SHALL CO-ORDINATE THE EXACT LOCATION KEEPING ALL SUCH EQUIPMENT AS CLOSE TO DOOR JAMBS AND OTHER OPENINGS AS POSSIBLE. WHEN MOUNTED ON ROLED STEEL COLUMNS ALL SUCH EQUIPMENT SHALL BE MOUNTED ON THE WEB OF THE COLUMN UNLESS NOTED OTHERWISE. THE CONTRACTOR SHALL ENSURE THAT THE LOCATIONS ARE APPROVED BY THE ARCHITECT BEFORE THE EQUIPMENT IS INSTALLED.

ALL METAL PARTS OF EQUIPMENT EXPOSED ON THE EXTERIOR OF THE BUILDING SHALL BE CO-ORDINATED BY THE CONTRACTOR TO RESERVE A UNIFORM COLOUR THROUGHOUT.

- NOTES:
- ALL FLUORESCENT FIXTURES ON THIS DRAWING SHALL BE TYPE A UNLESS OTHERWISE NOTED.
 - FOR WIRING DIAGRAM OF FLUORESCENT DIMMING SYSTEM AS SHOWN ON SHEET REFER TO 1A-525.

No.	Ref.	Description	Date	Ch'd
1		REV. FOR 5-149	1-1-71	
2		REV. FOR 5-149	1-1-71	
3		REV. FOR 5-149	1-1-71	
4		REV. FOR 5-149	1-1-71	

Revisions	
Drawn	G.M.V.V.W.
Date	5 FEB 1971
Checked	C.A.
Pre-Design	
Design	P.J.
Architectural	J.M.R.
Structural	B.J.
Heating	A.V.
Sanitary	A.V.
Electrical	C.A.
Specifications	R.
Process	
Printed	JAN 15 1971

All measurements must be checked on the work by the contractor.

All prints and specifications are the property of the architects and must be returned at the completion of the work.

This drawing not to be used for construction purposes until countersigned by:

Date: 21 MAY 71

NATIONAL LIFE OF CANADA

Head Office Building
University Avenue, Toronto, Canada

This drawing is the property of
Neish Owen Rowland & Roy

Searle Wilbee Rowland
Architects
Engineers
Planners
Toronto
Canada

ELECTRICAL
5TH FLOOR PLAN
LIGHTING

Sheet
Title
Copyright ©
Scale: 1/8" = 1'-0"
Sheet Number: 69039-510