


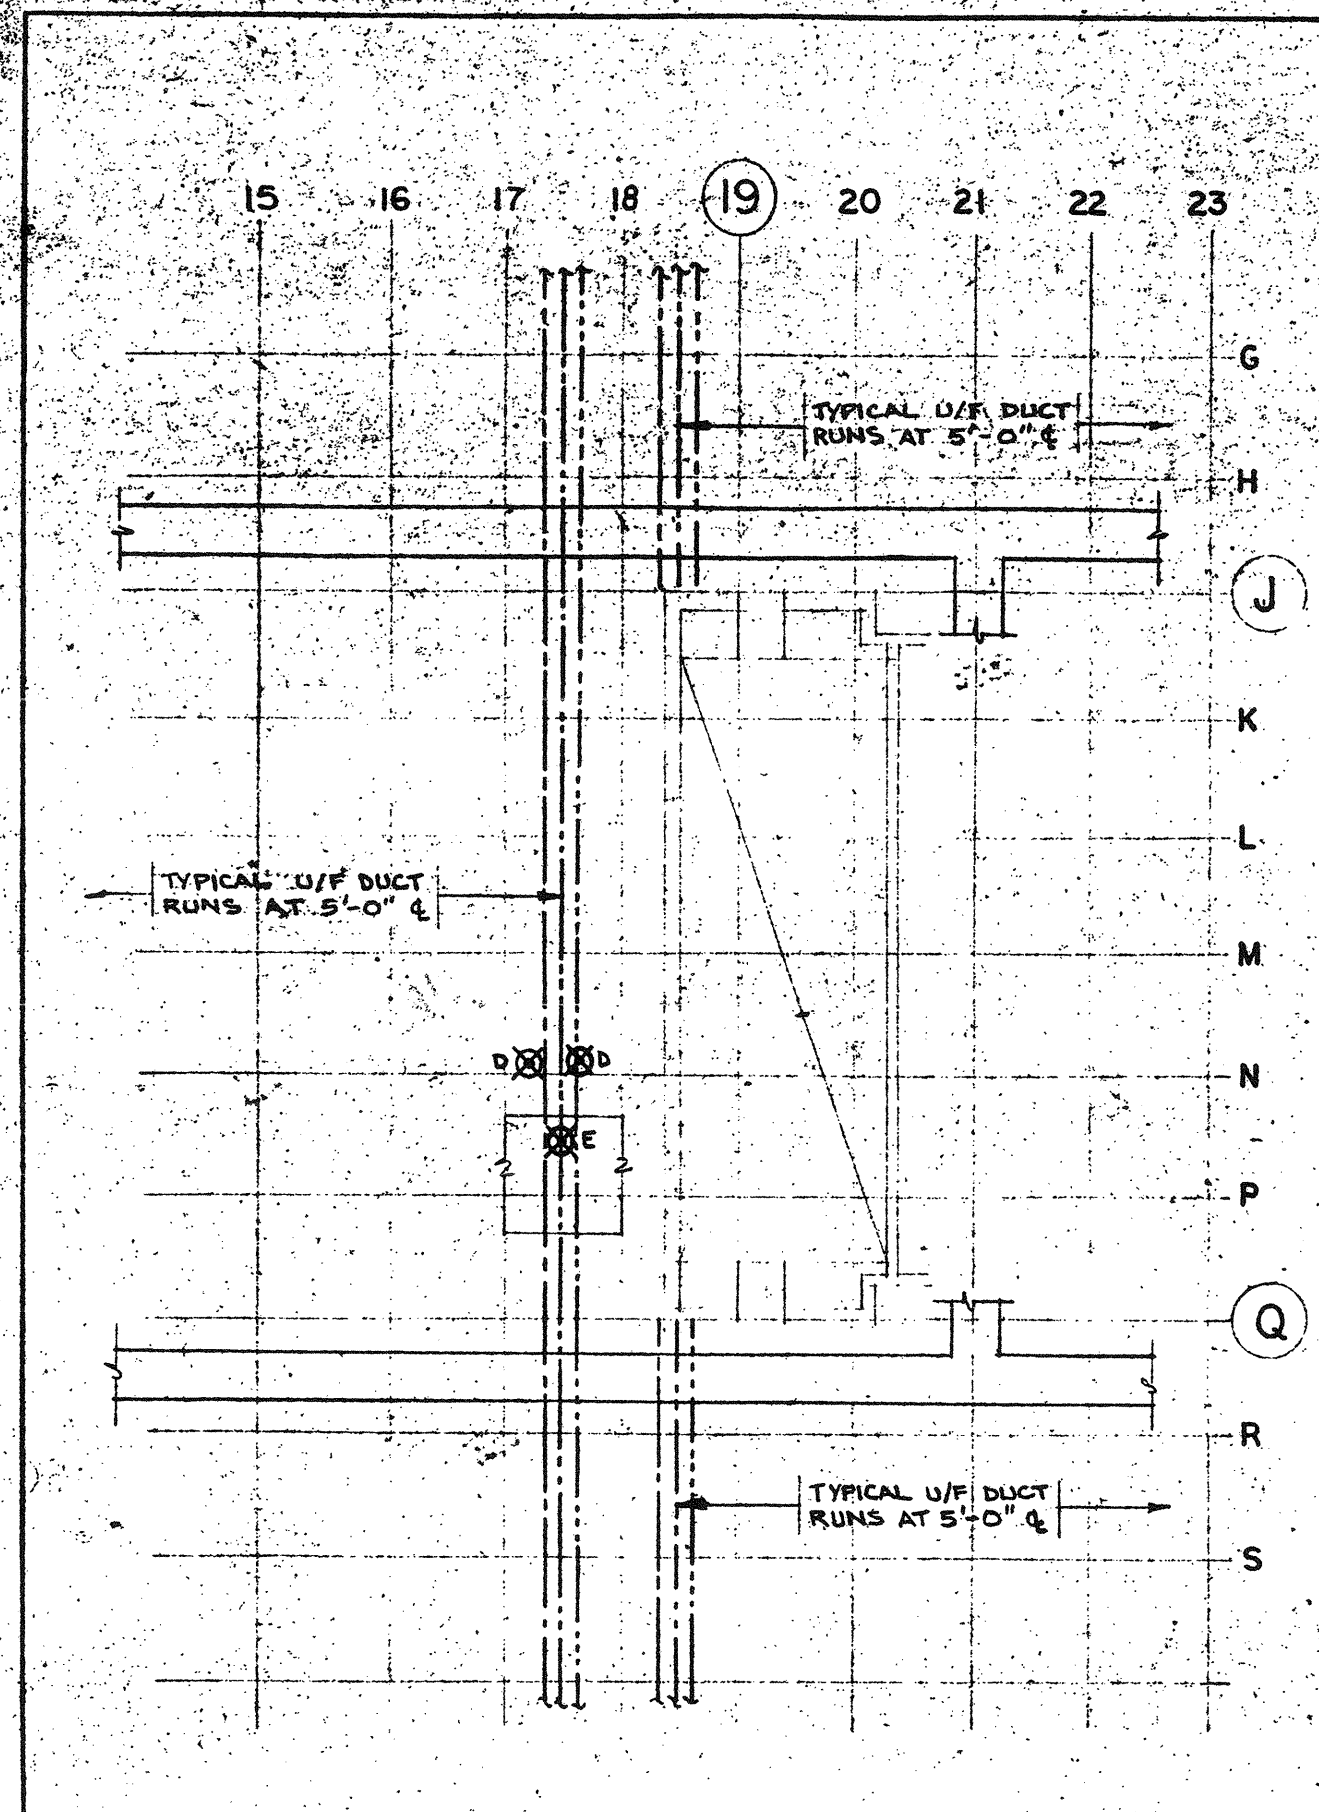


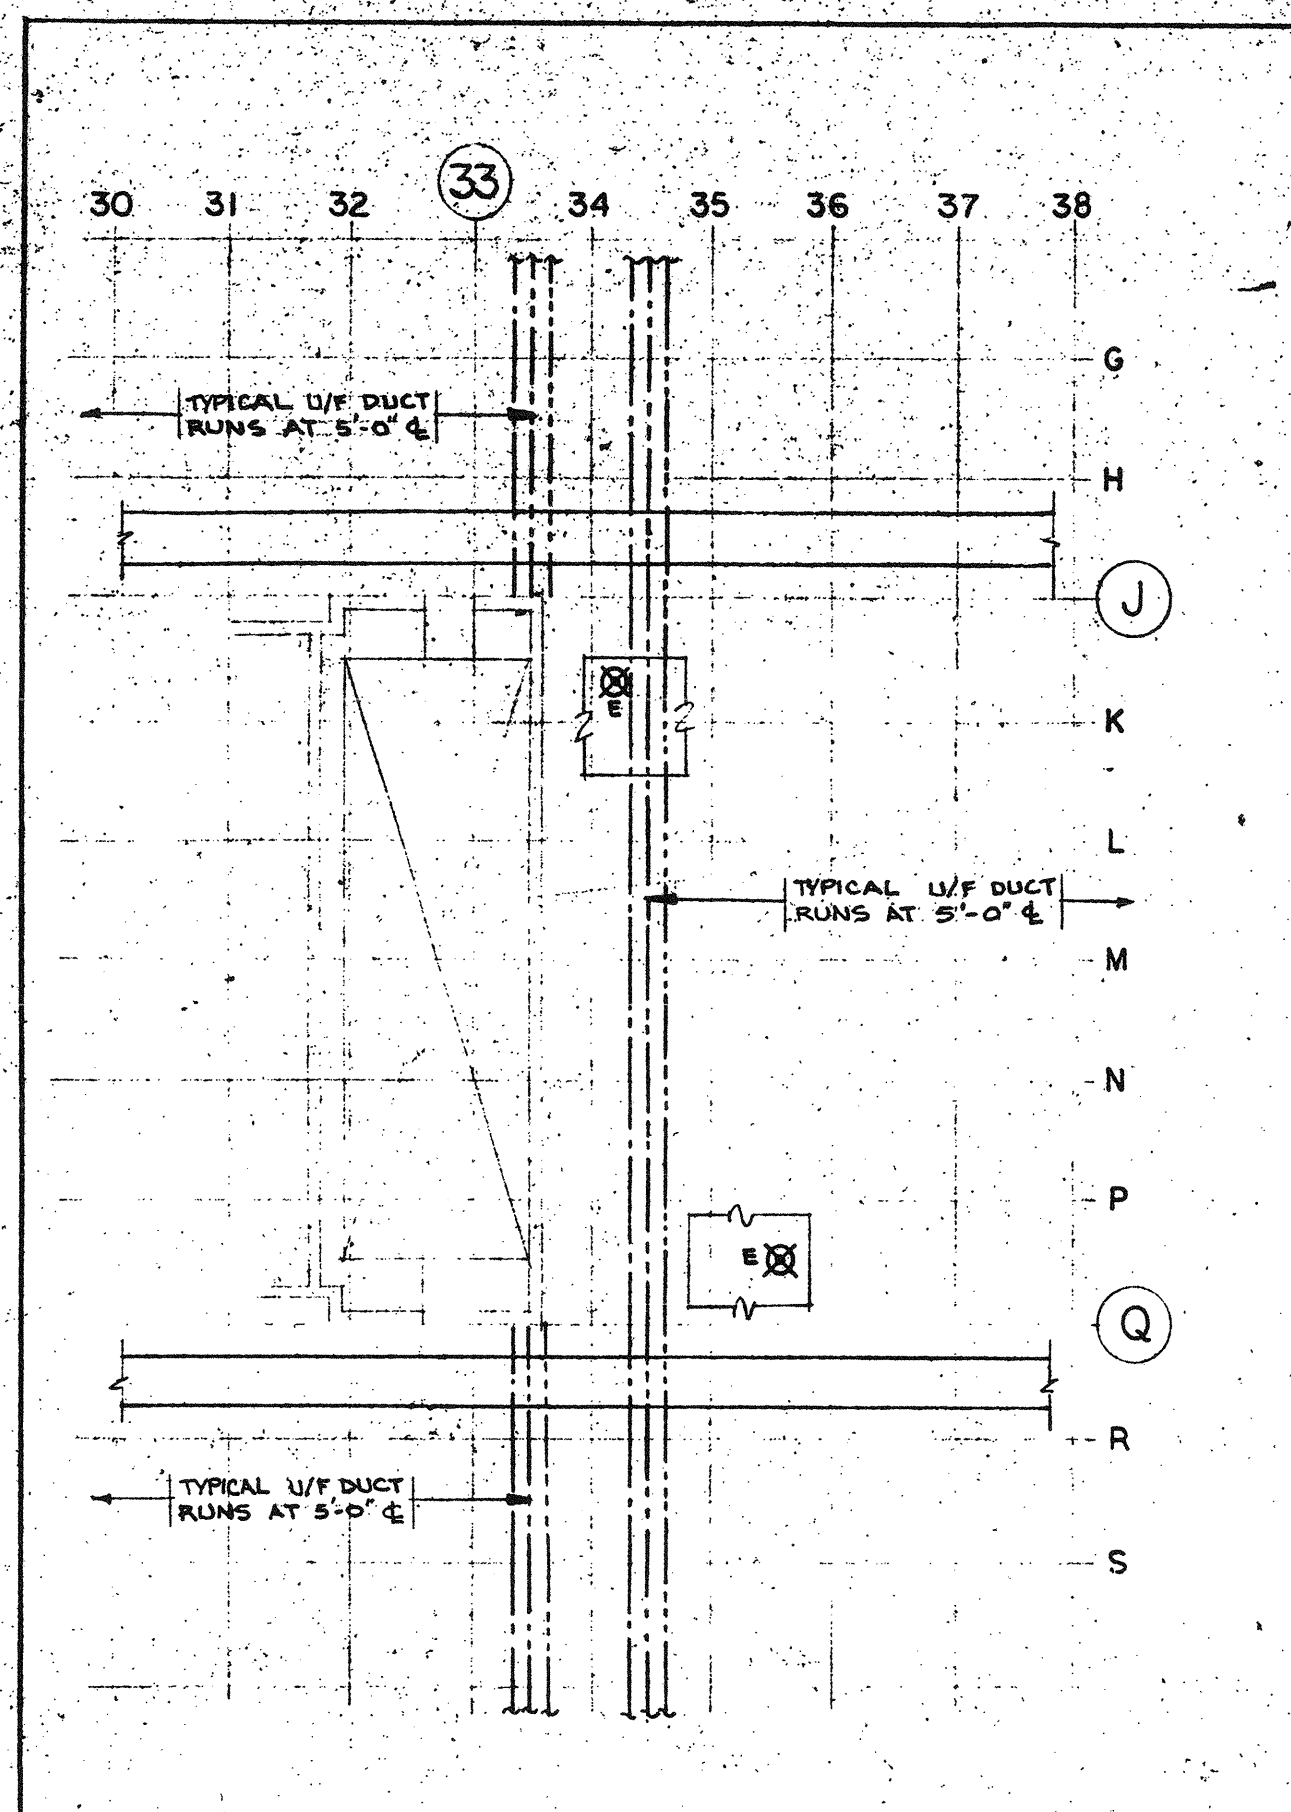

1 PART 10TH TO 14TH FLOORS POWER AROUND CORE
SCALE: 1/8"=1'-0"

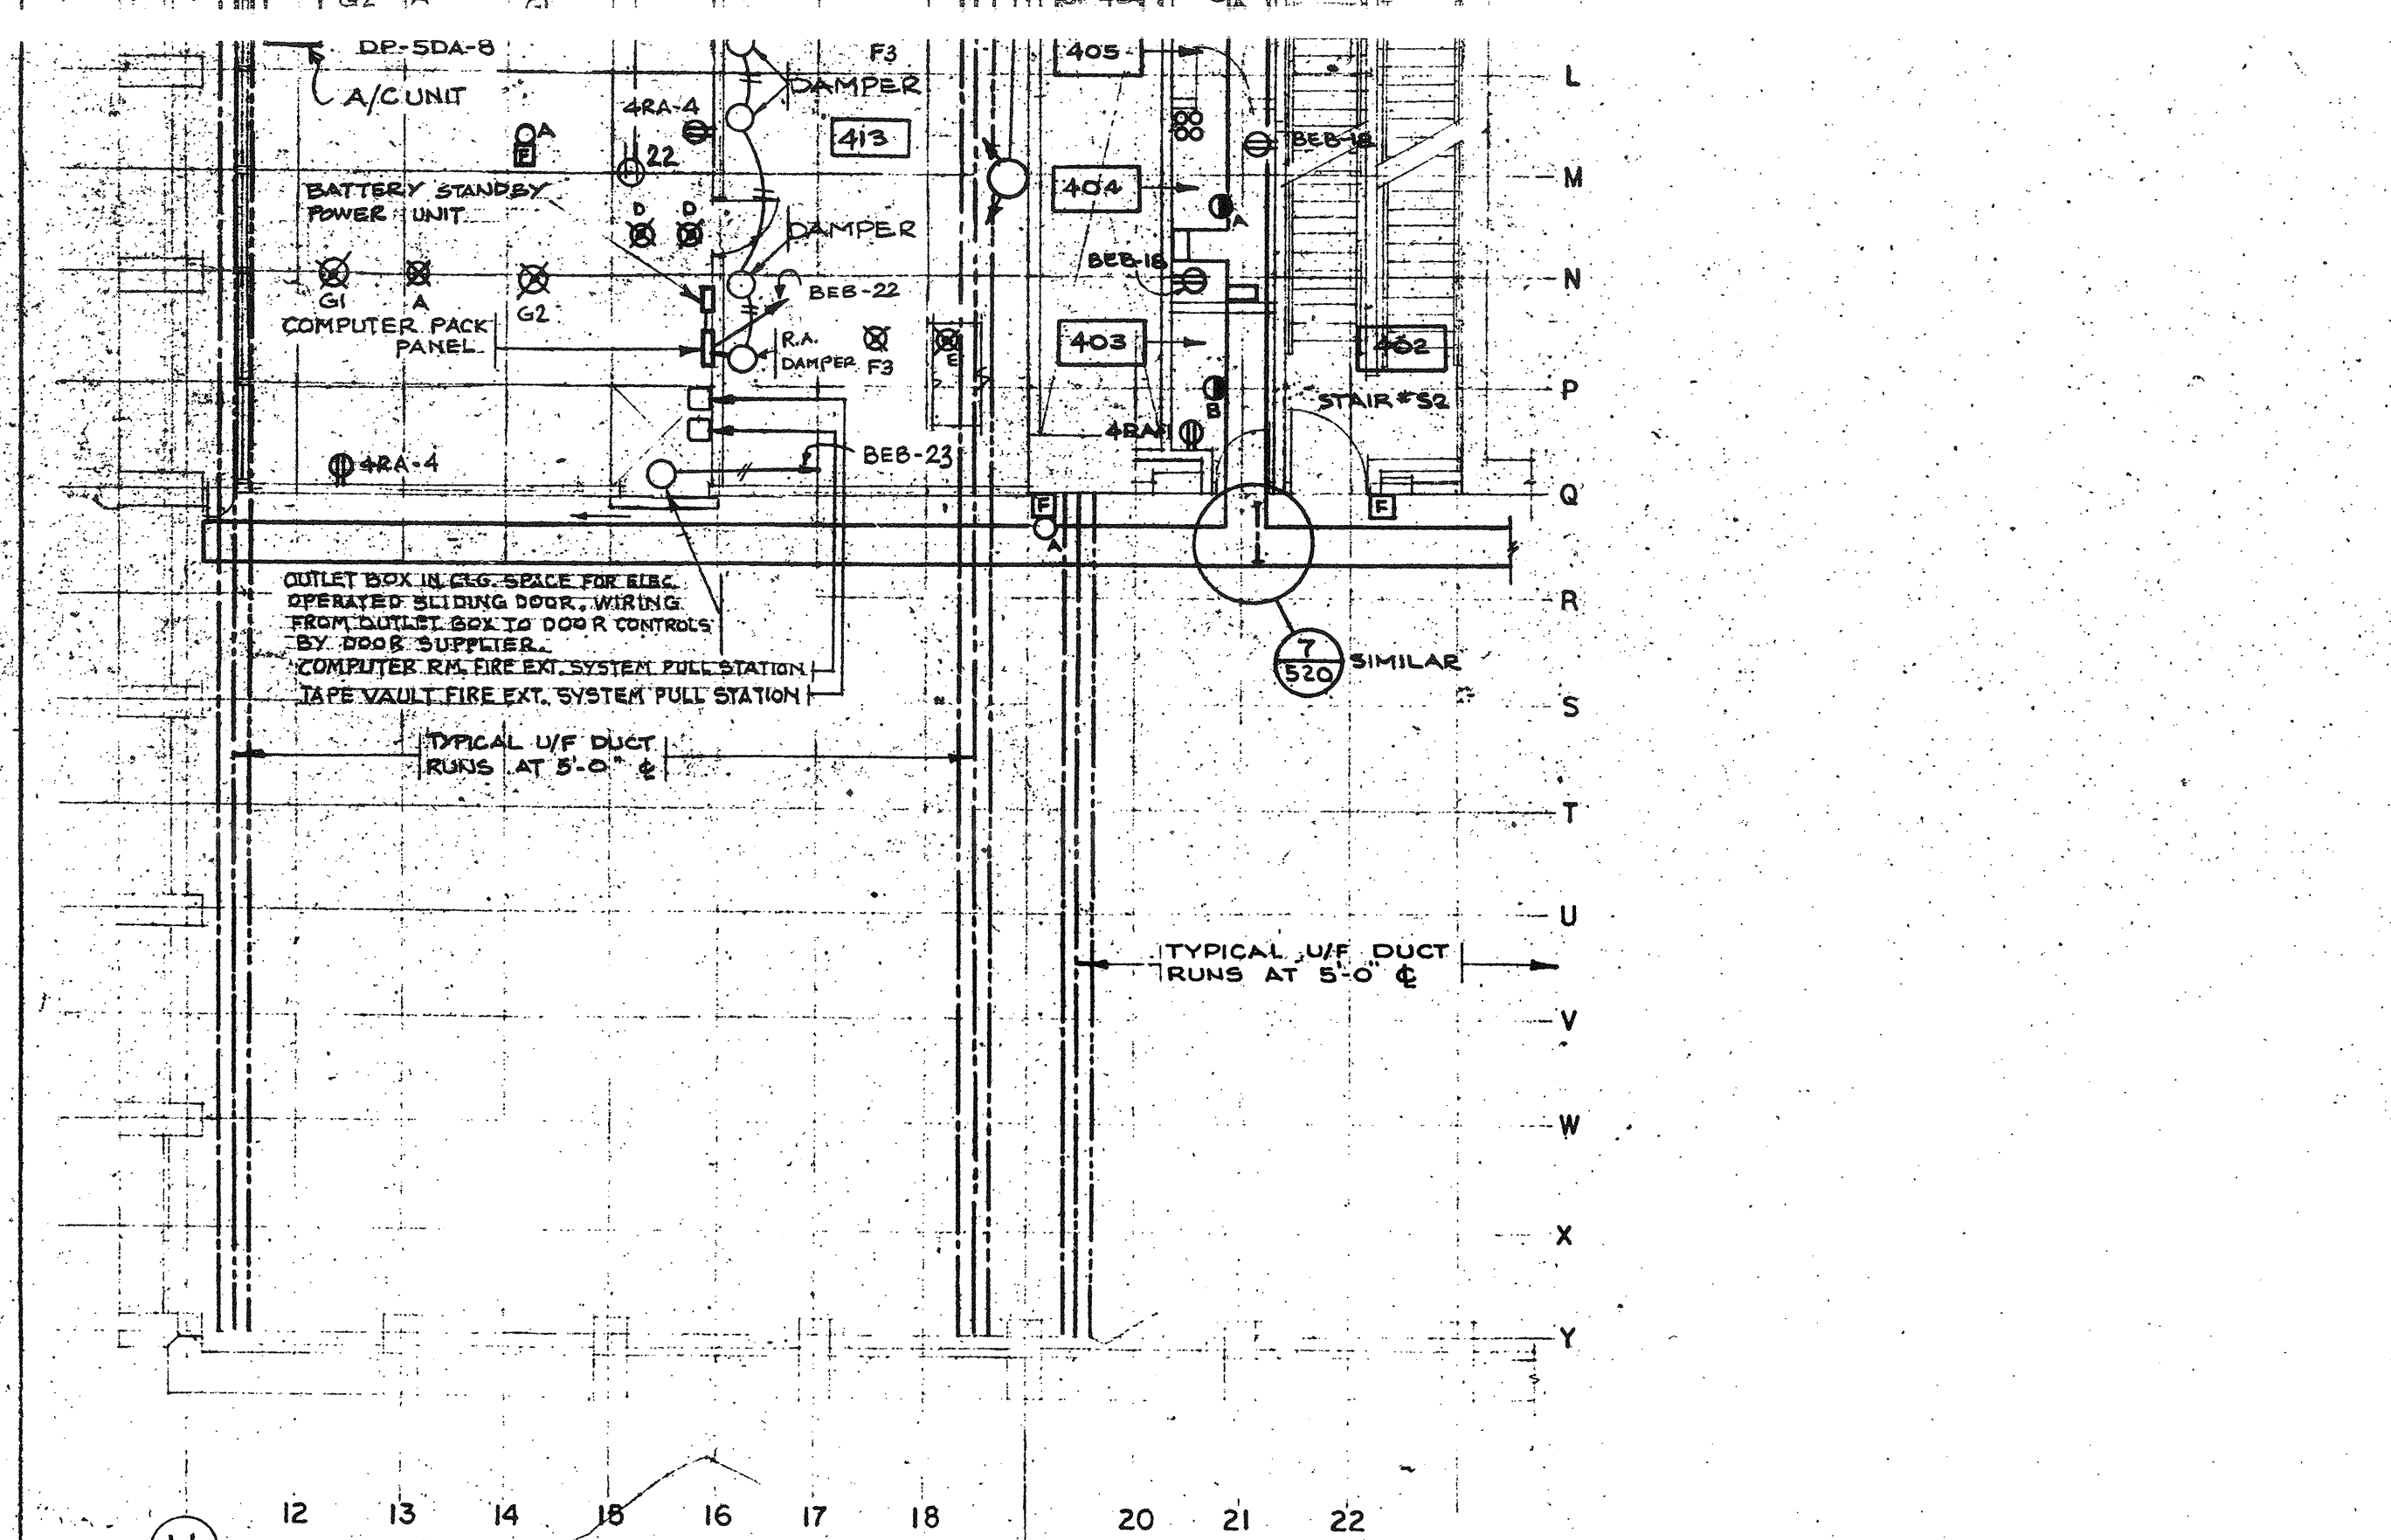


2 PART 10TH TO 14TH FLOORS POWER AROUND CORE
SCALE: 1/8"=1'-0"

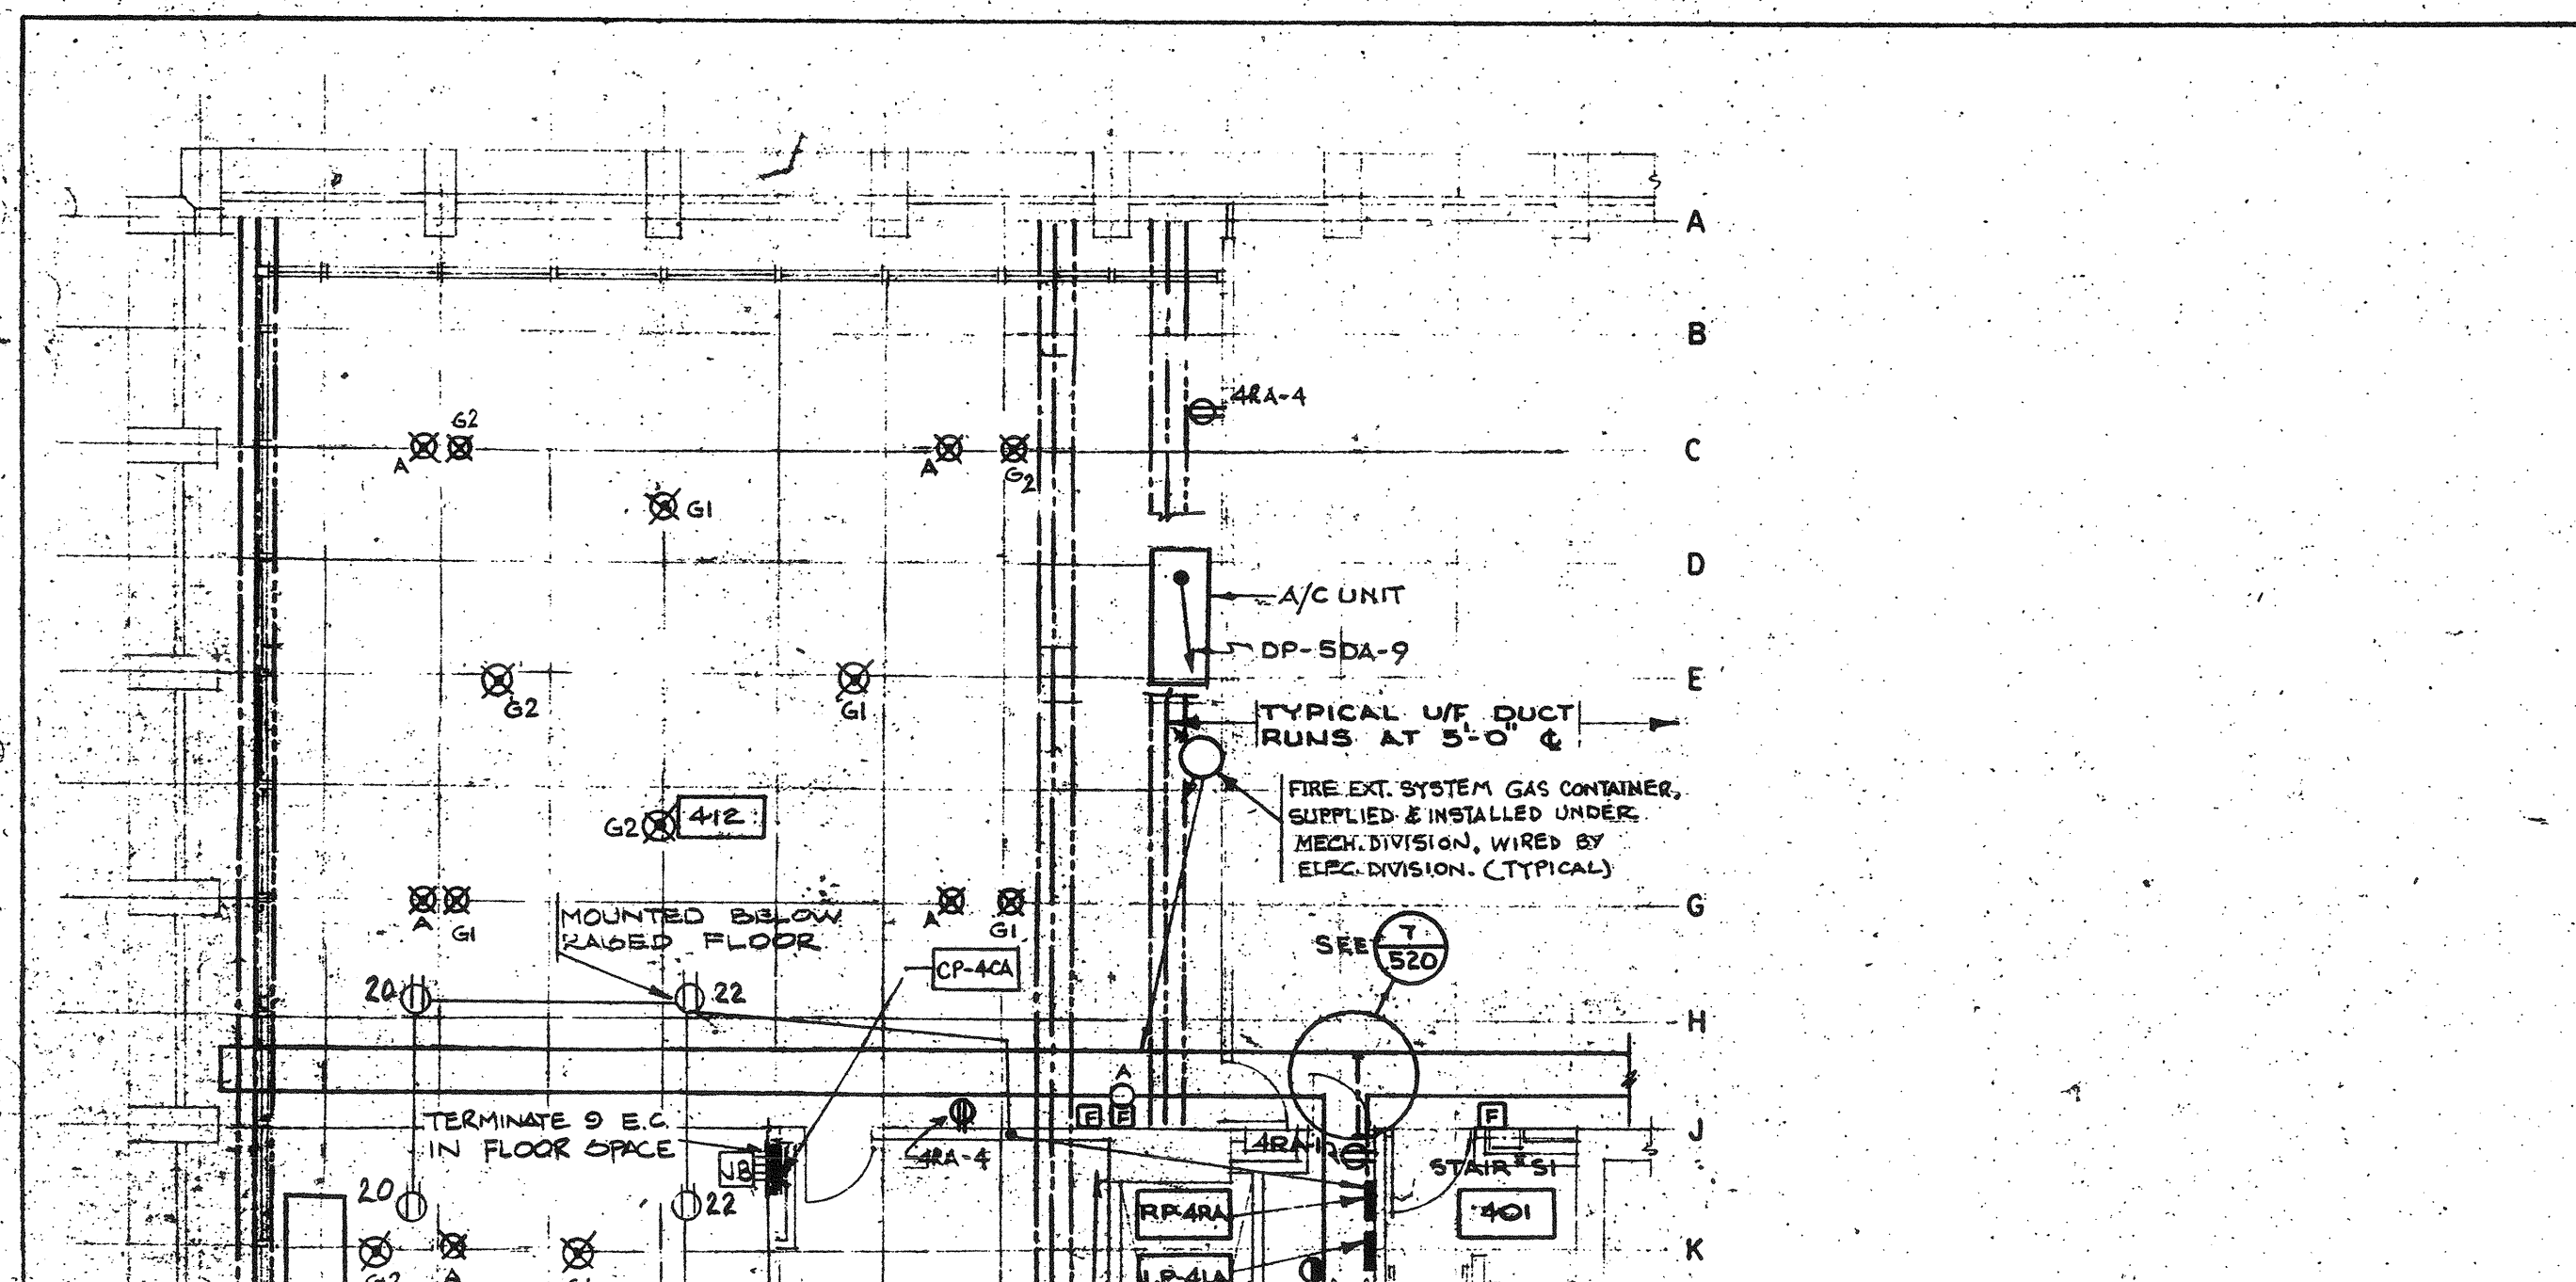

3 PART 4TH FLOOR POWER (COMPUTER AREA)
SCALE: 1/8"=1'-0"

SYMBOL	DESCRIPTION
⊗	SMOKE DETECTOR - CEILING MOUNTED. (CONNECTED TO BUILDING SMOKE DET. SYSTEM)
⊗	SMOKE DETECTOR - CEILING MOUNTED. (CONNECTED TO COMPUTER PACK PANEL)
⊗	SMOKE DETECTOR - MOUNTED UNDER RAISED FLOOR. (CONNECTED TO COMPUTER PACK PANEL)

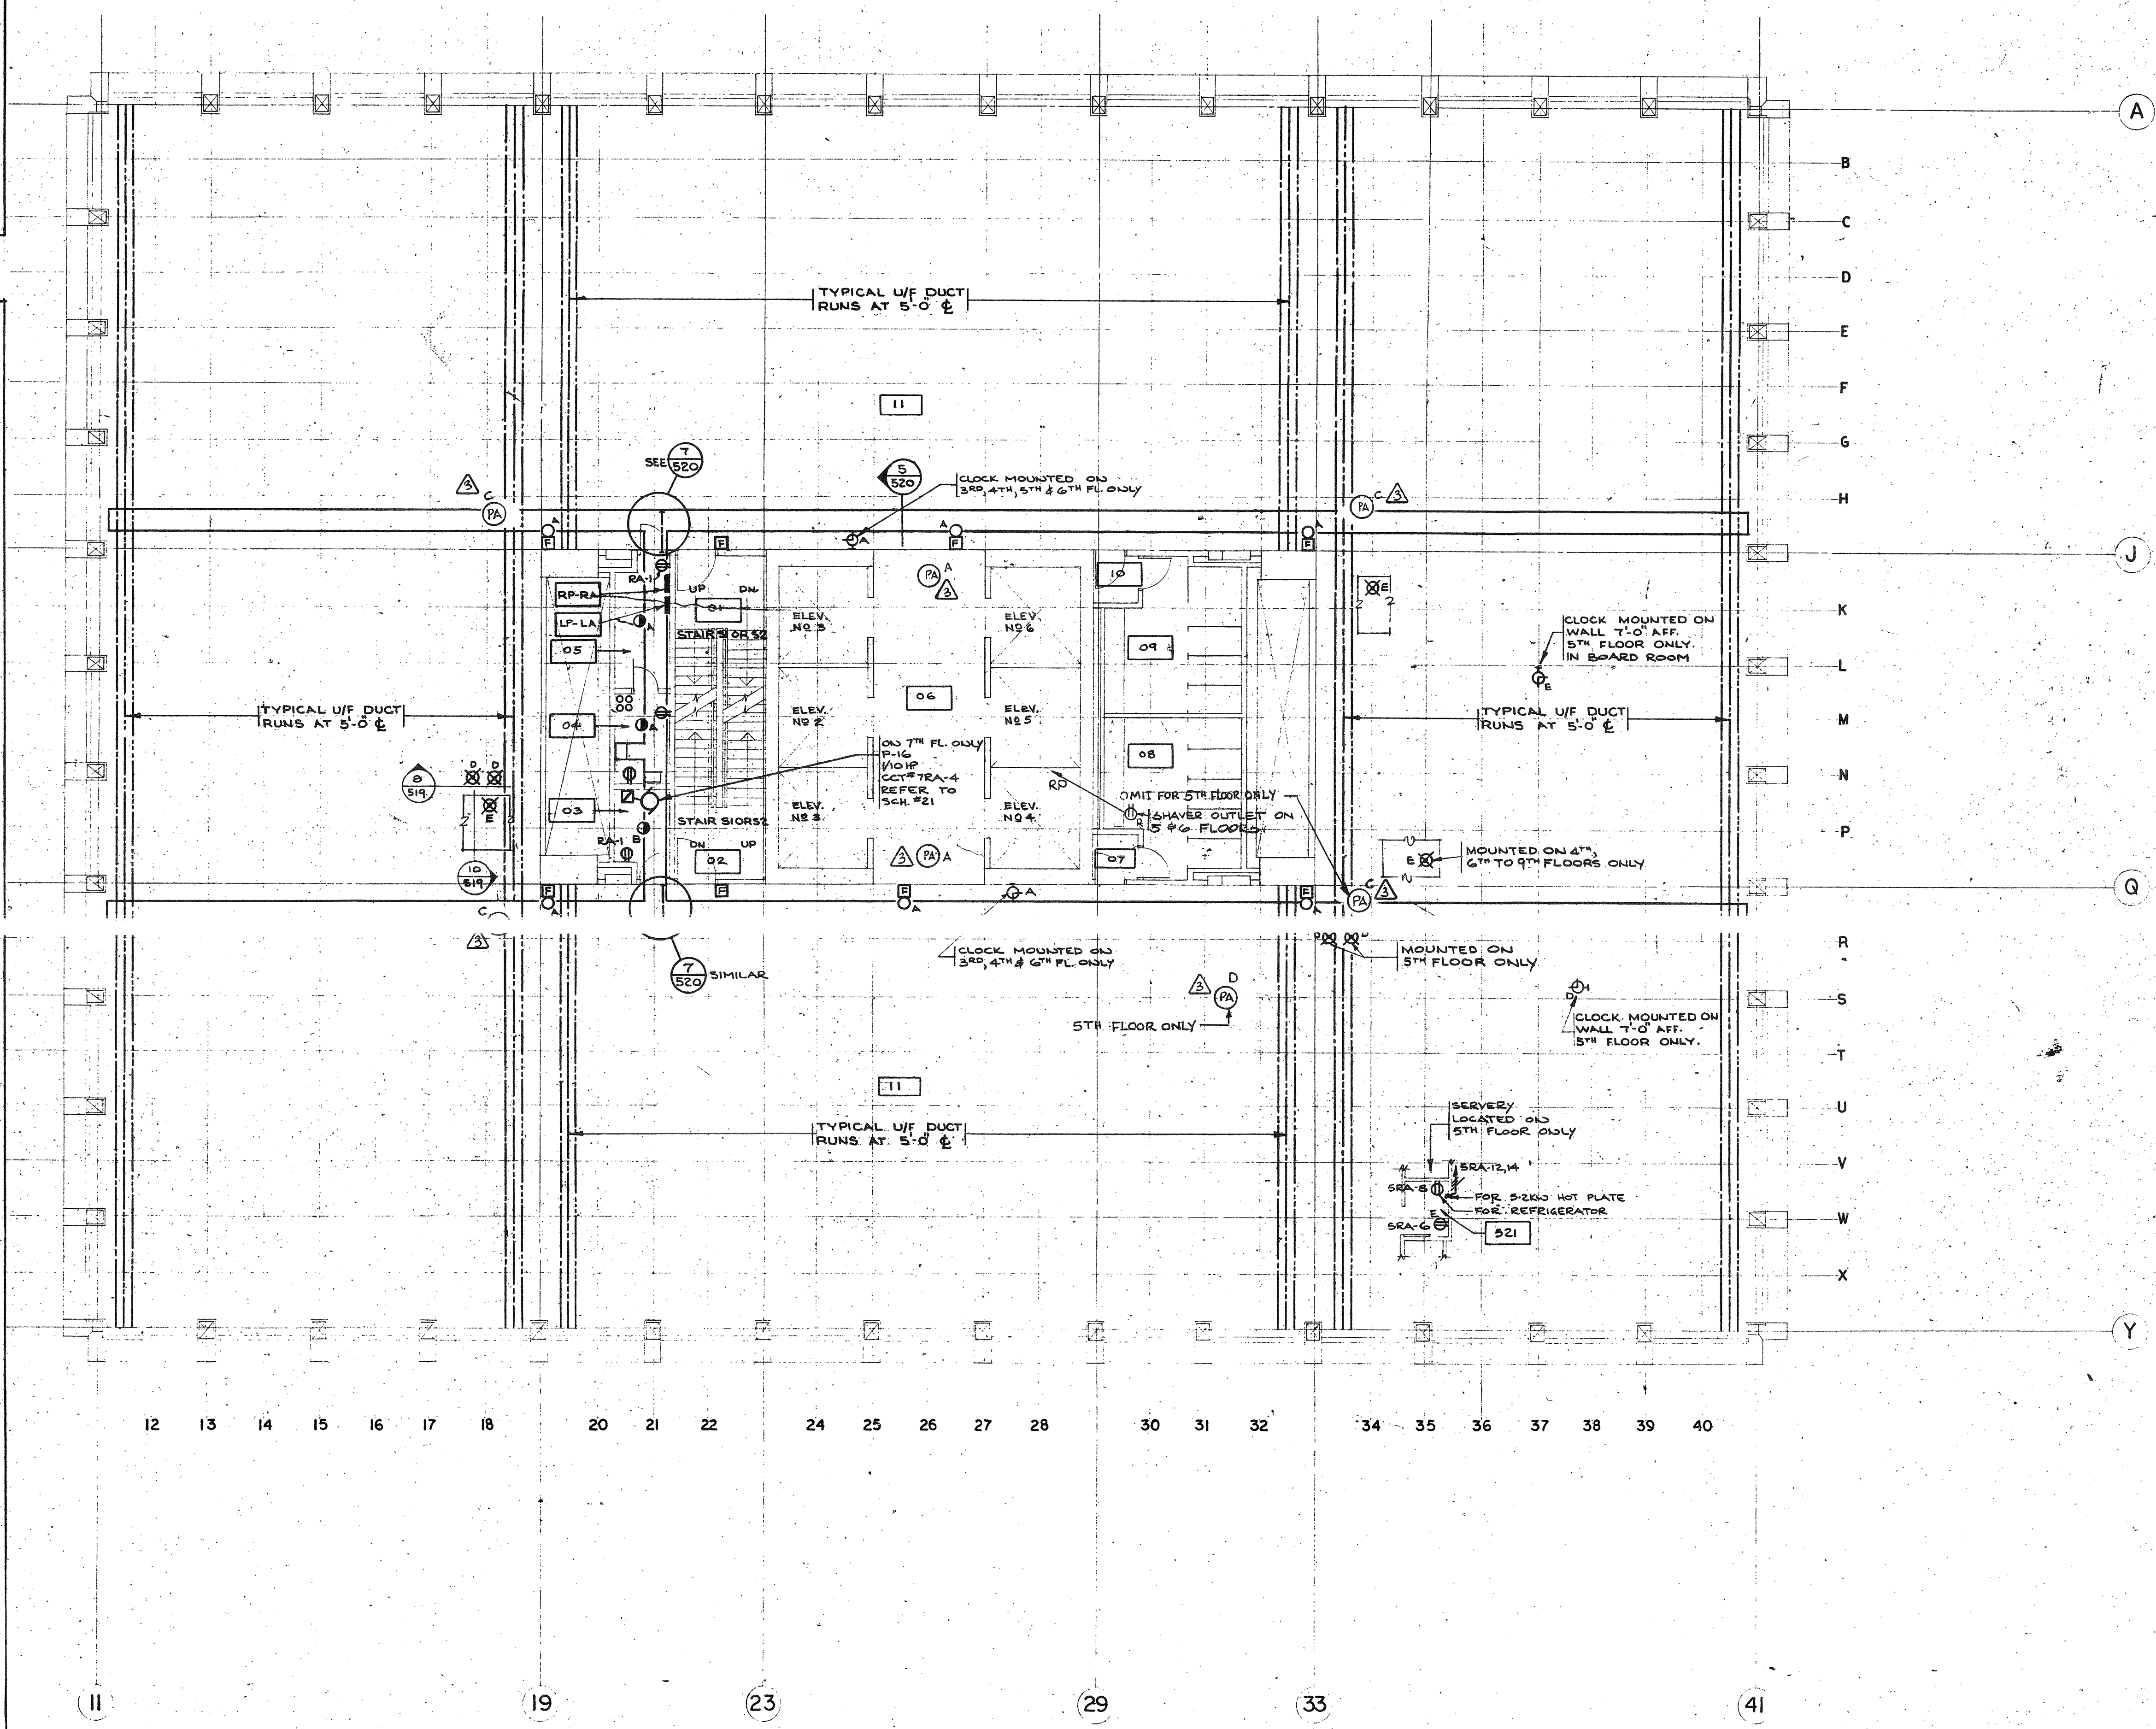

THE LOCATION OF EQUIPMENT SHALL BE COORDINATED WITH THE CONTRACTOR TO ENSURE THAT THE LOCATION IS APPROVED BY THE ARCHITECT BEFORE THE EQUIPMENT IS INSTALLED. THE LOCATION OF EQUIPMENT SUCH AS SWITCHES, THERMOSTATS AND CONTROLS IS SHOWN IN DIAGRAMATIC FORM. THE CONTRACTOR SHALL COORDINATE THE EXACT LOCATION, KEEPING ALL SUCH EQUIPMENT AS CLOSE TO FLOOR JAMB AND OTHER OBSTACLES AS POSSIBLE. WHEN MOUNTED ON ROLLED STEEL COLUMNS ALL SUCH EQUIPMENT SHALL BE MOUNTED ON THE WEB OF THE COLUMN UNLESS NOTED OTHERWISE. THE CONTRACTOR SHALL ENSURE THAT THE LOCATIONS ARE APPROVED BY THE ARCHITECT BEFORE THE EQUIPMENT IS INSTALLED. ALL METAL PARTS OF EQUIPMENT EXPOSED ON THE EXTERIOR OF THE BUILDING SHALL BE COORDINATED BY THE CONTRACTOR TO PRESERVE A UNIFORM COLOUR THROUGHOUT.

NOTES:
1. FOR EQUIPMENT LAYOUT DETAILS OF ROOMS 308, 309 & 310 (TYPICAL FLOORS) REFER TO DWG. 69039-515.
2. CIRCUITS FOR RECEPTACLES IN TELEPHONE ROOMS 308, 309 & 310 ON TYPICAL FLOORS SHALL BE AS FOLLOWS:
3RD FLOOR - SEE 5-15
4TH FLOOR - SEE 5-2
5TH FLOOR - SEE 5-7
6TH FLOOR - SEE 5-3
7TH FLOOR - SEE 5-10
8TH FLOOR - SEE 5-8
9TH FLOOR - SEE 5-10
10TH FLOOR - SEE 5-12
11TH FLOOR - SEE 5-10
12TH FLOOR - SEE 5-9
13TH FLOOR - SEE 5-11
14TH FLOOR - SEE 5-11

No.	Rev.	Description	Date	Ch'd
1	1	REV. FOR BUILDING 1, 2, 3, 4	10/11/71	CA
2	2	REV. FOR 2, 3, 4, 5, 6, 7, 8, 9, 10, 11, 12, 13, 14, 15, 16, 17, 18, 19, 20, 21, 22, 23, 24, 25, 26, 27, 28, 29, 30, 31, 32, 33, 34, 35, 36, 37, 38, 39, 40	10/11/71	CA
3	3	REV. FOR 2, 3, 4, 5, 6, 7, 8, 9, 10, 11, 12, 13, 14, 15, 16, 17, 18, 19, 20, 21, 22, 23, 24, 25, 26, 27, 28, 29, 30, 31, 32, 33, 34, 35, 36, 37, 38, 39, 40	10/11/71	CA
4	4	REV. FOR 2, 3, 4, 5, 6, 7, 8, 9, 10, 11, 12, 13, 14, 15, 16, 17, 18, 19, 20, 21, 22, 23, 24, 25, 26, 27, 28, 29, 30, 31, 32, 33, 34, 35, 36, 37, 38, 39, 40	10/11/71	CA
5	5	REV. FOR 2, 3, 4, 5, 6, 7, 8, 9, 10, 11, 12, 13, 14, 15, 16, 17, 18, 19, 20, 21, 22, 23, 24, 25, 26, 27, 28, 29, 30, 31, 32, 33, 34, 35, 36, 37, 38, 39, 40	10/11/71	CA

No.	Rev.	Description	Date	Ch'd
1	1	REV. FOR BUILDING 1, 2, 3, 4	10/11/71	CA
2	2	REV. FOR 2, 3, 4, 5, 6, 7, 8, 9, 10, 11, 12, 13, 14, 15, 16, 17, 18, 19, 20, 21, 22, 23, 24, 25, 26, 27, 28, 29, 30, 31, 32, 33, 34, 35, 36, 37, 38, 39, 40	10/11/71	CA
3	3	REV. FOR 2, 3, 4, 5, 6, 7, 8, 9, 10, 11, 12, 13, 14, 15, 16, 17, 18, 19, 20, 21, 22, 23, 24, 25, 26, 27, 28, 29, 30, 31, 32, 33, 34, 35, 36, 37, 38, 39, 40	10/11/71	CA
4	4	REV. FOR 2, 3, 4, 5, 6, 7, 8, 9, 10, 11, 12, 13, 14, 15, 16, 17, 18, 19, 20, 21, 22, 23, 24, 25, 26, 27, 28, 29, 30, 31, 32, 33, 34, 35, 36, 37, 38, 39, 40	10/11/71	CA
5	5	REV. FOR 2, 3, 4, 5, 6, 7, 8, 9, 10, 11, 12, 13, 14, 15, 16, 17, 18, 19, 20, 21, 22, 23, 24, 25, 26, 27, 28, 29, 30, 31, 32, 33, 34, 35, 36, 37, 38, 39, 40	10/11/71	CA

All measurements must be checked on the work by the contractor.
All prints and specifications are the property of the architect and must be returned at the completion of the work.
This drawing not to be used for construction purposes until countersigned by:
Date: 21 May 71

NATIONAL LIFE OF CANADA
Head Office Building
University Avenue, Toronto, Canada

Searle Wilbee Rowland
Architects
Engineers
Planners
Toronto
Canada

This drawing is the property of
North Owen Rowland & Roy
ELECTRICAL
TYPICAL FLOOR PLAN
3RD TO 14TH
POWER
Sheet
Title
Scale
1/8" = 1'-0"
Sheet Number
69039-512