




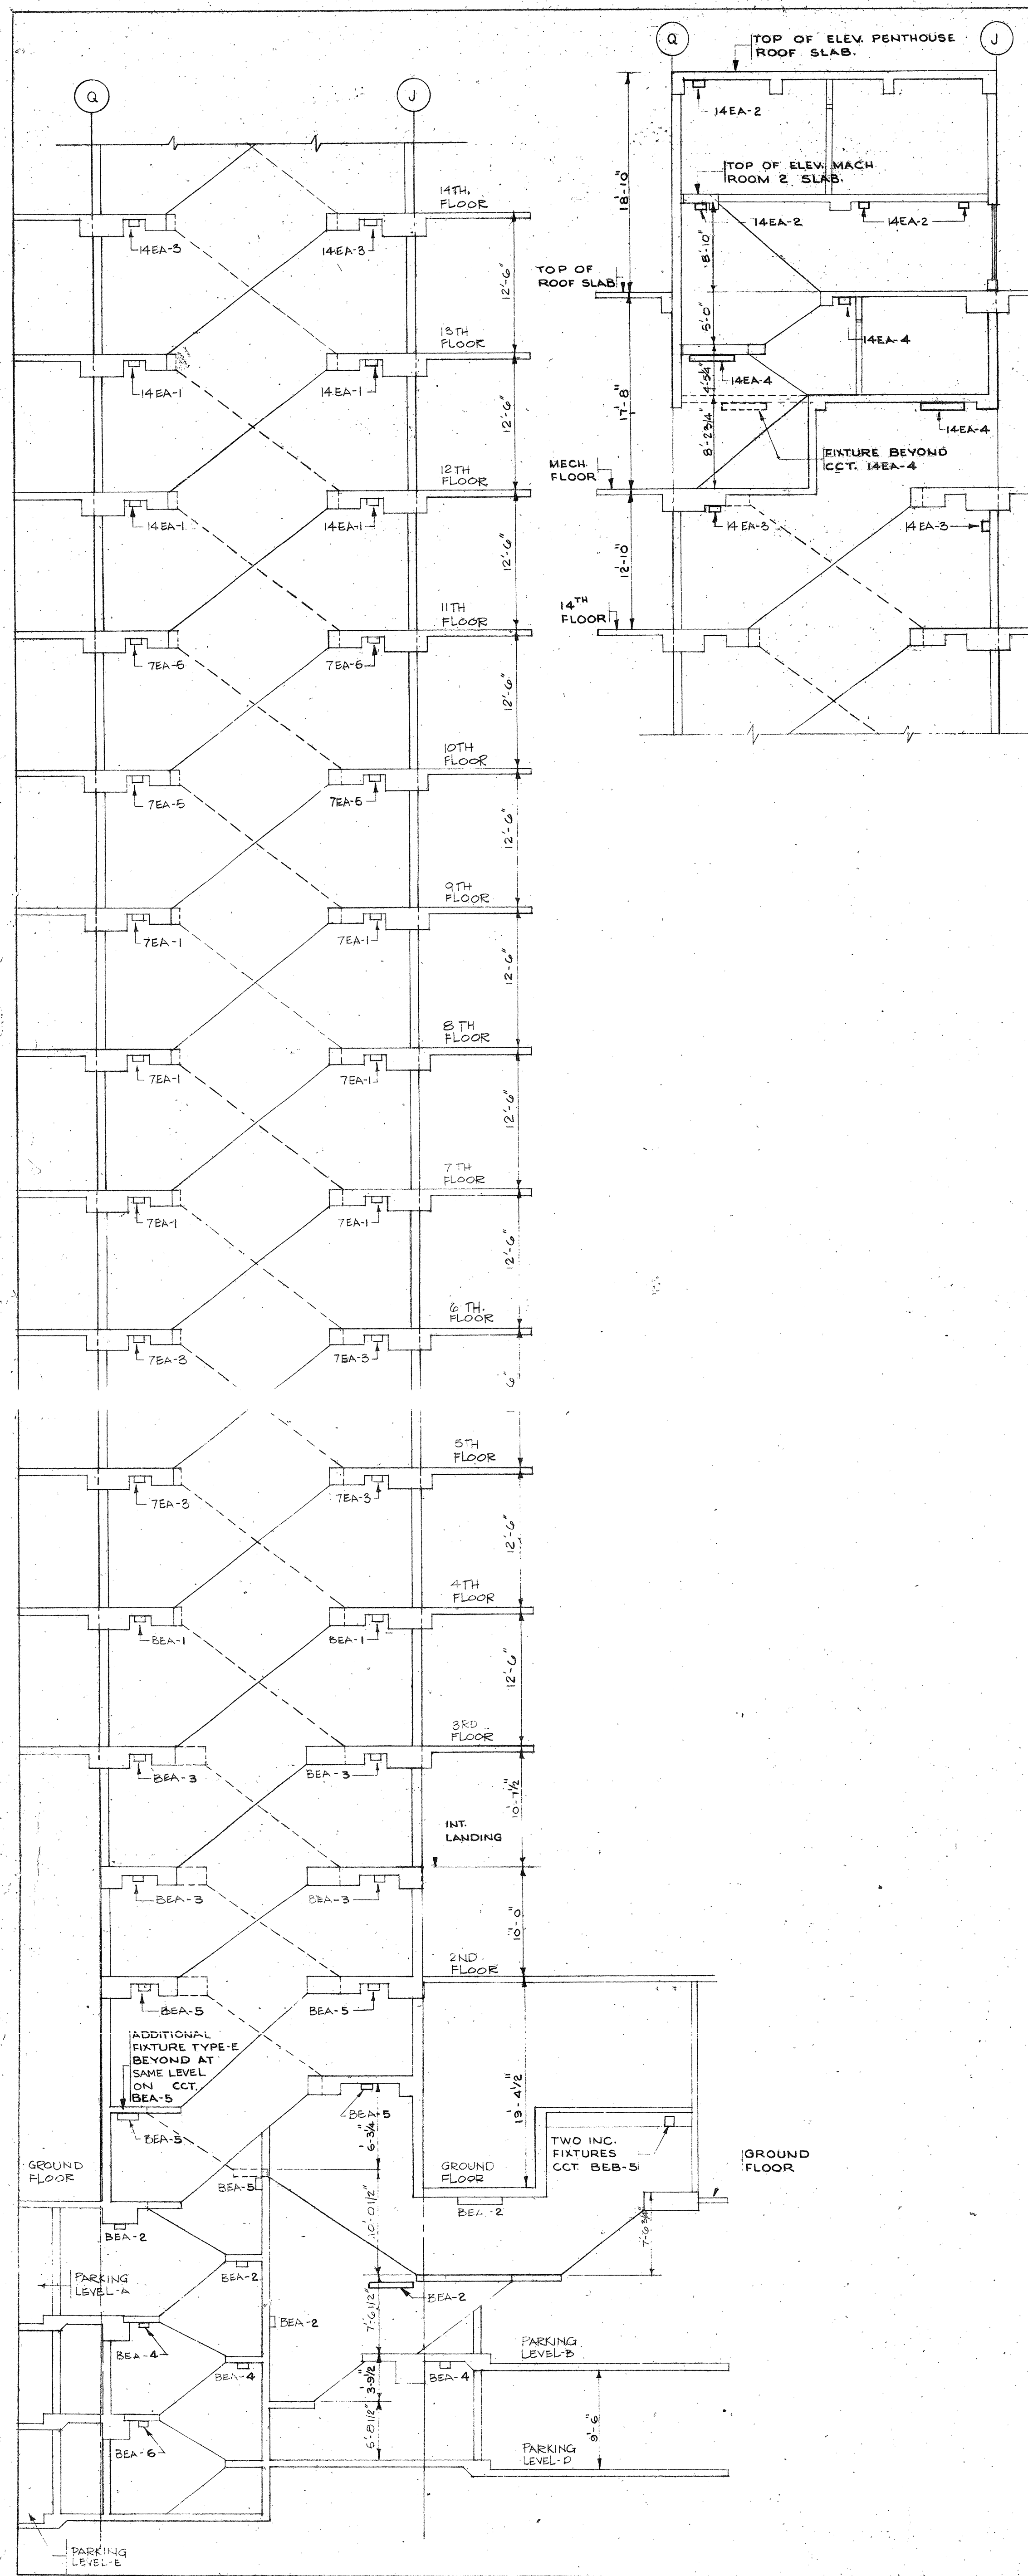


1 STAIRS, S1, S2 AND S6 LIGHTING RISER
SCALE: 1/8"=1'-0"

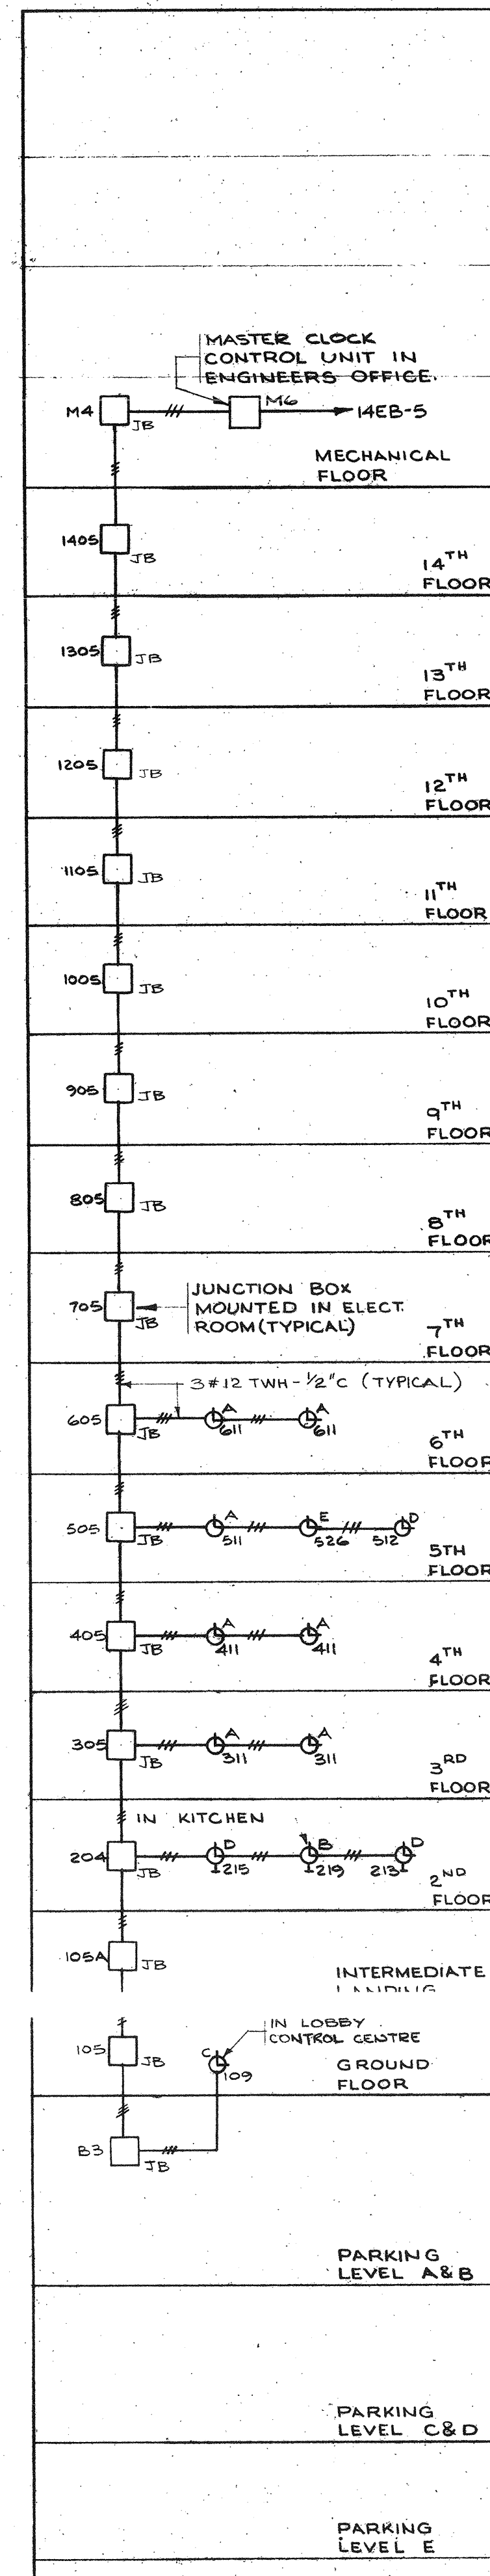


2 MASTER CLOCK SYSTEM RISER
N.T.S.

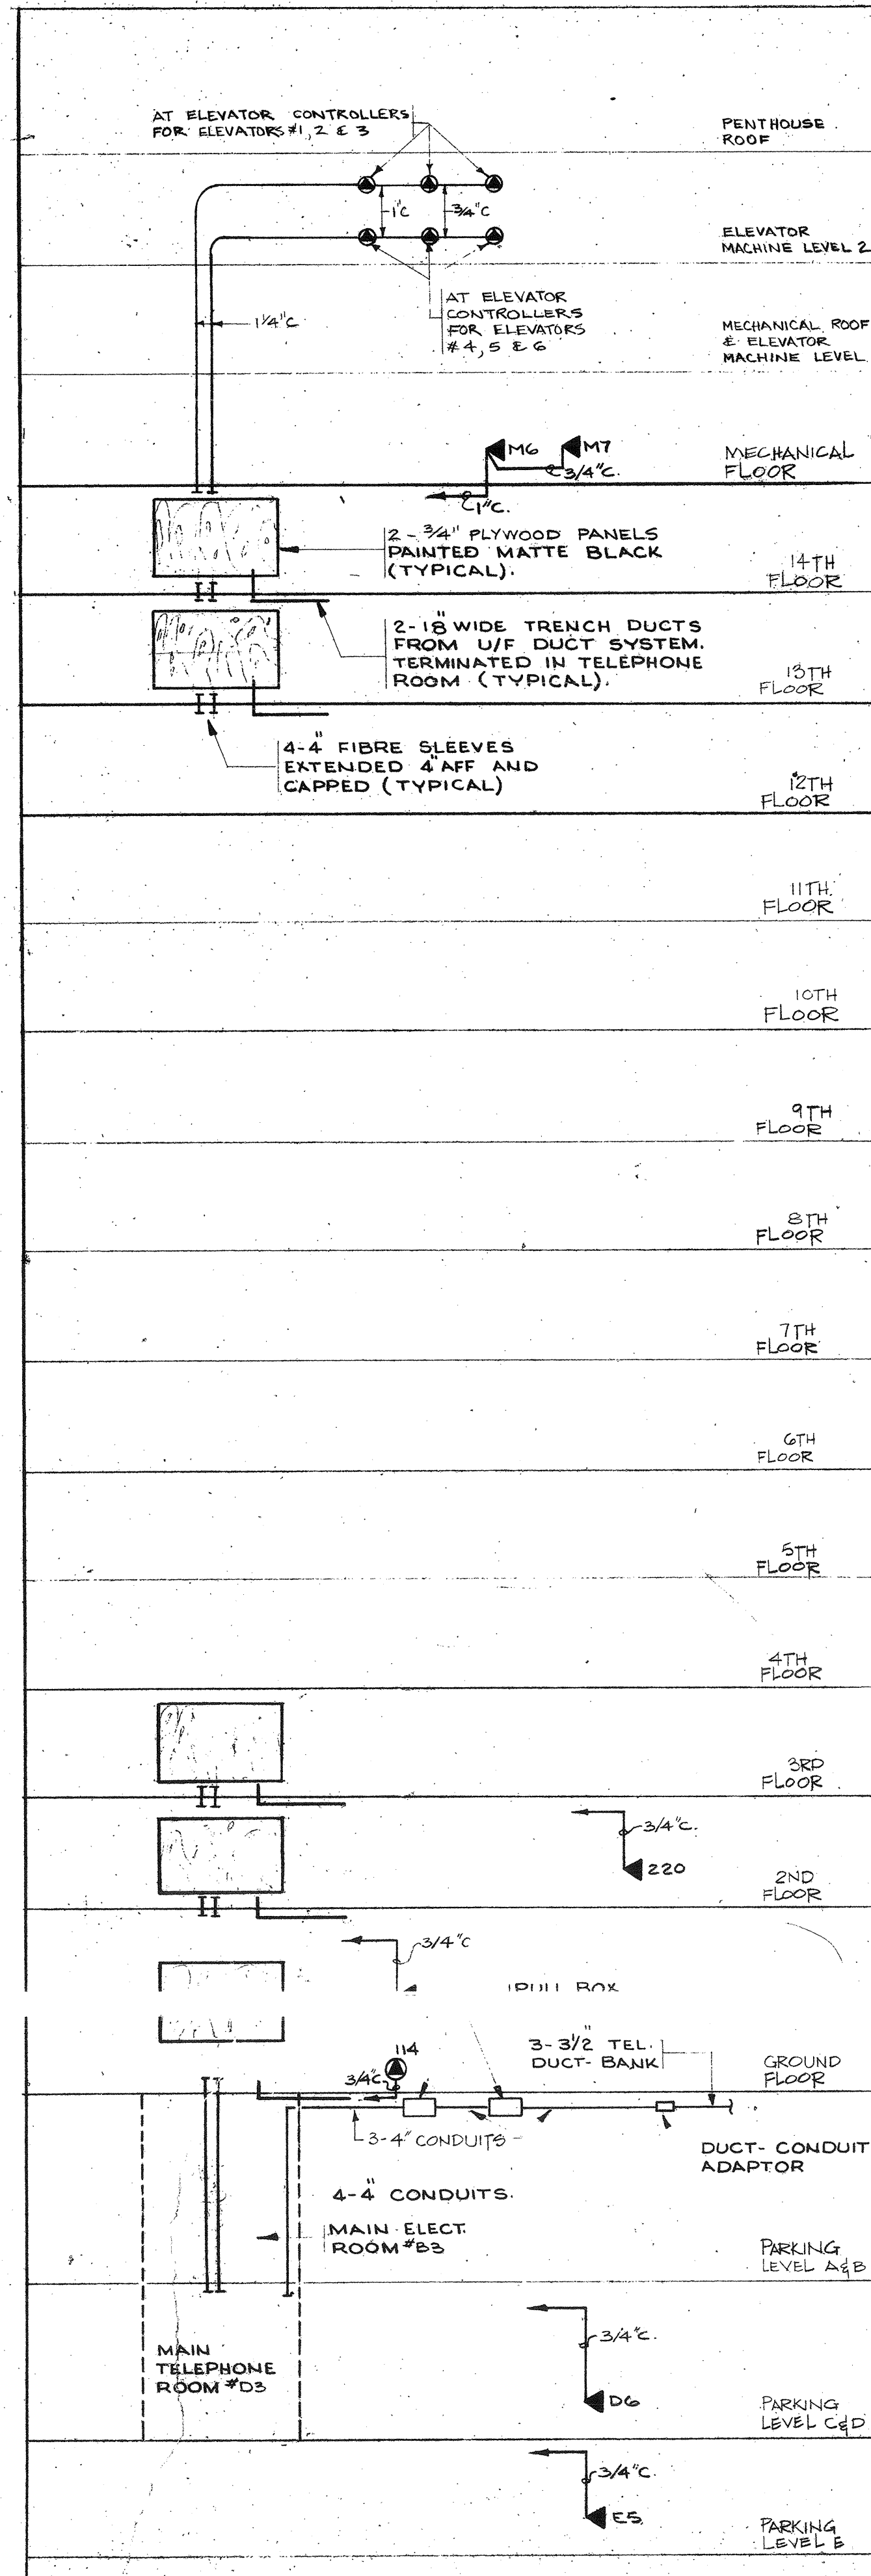


3 TELEPHONE SYSTEM RISER
N.T.S.

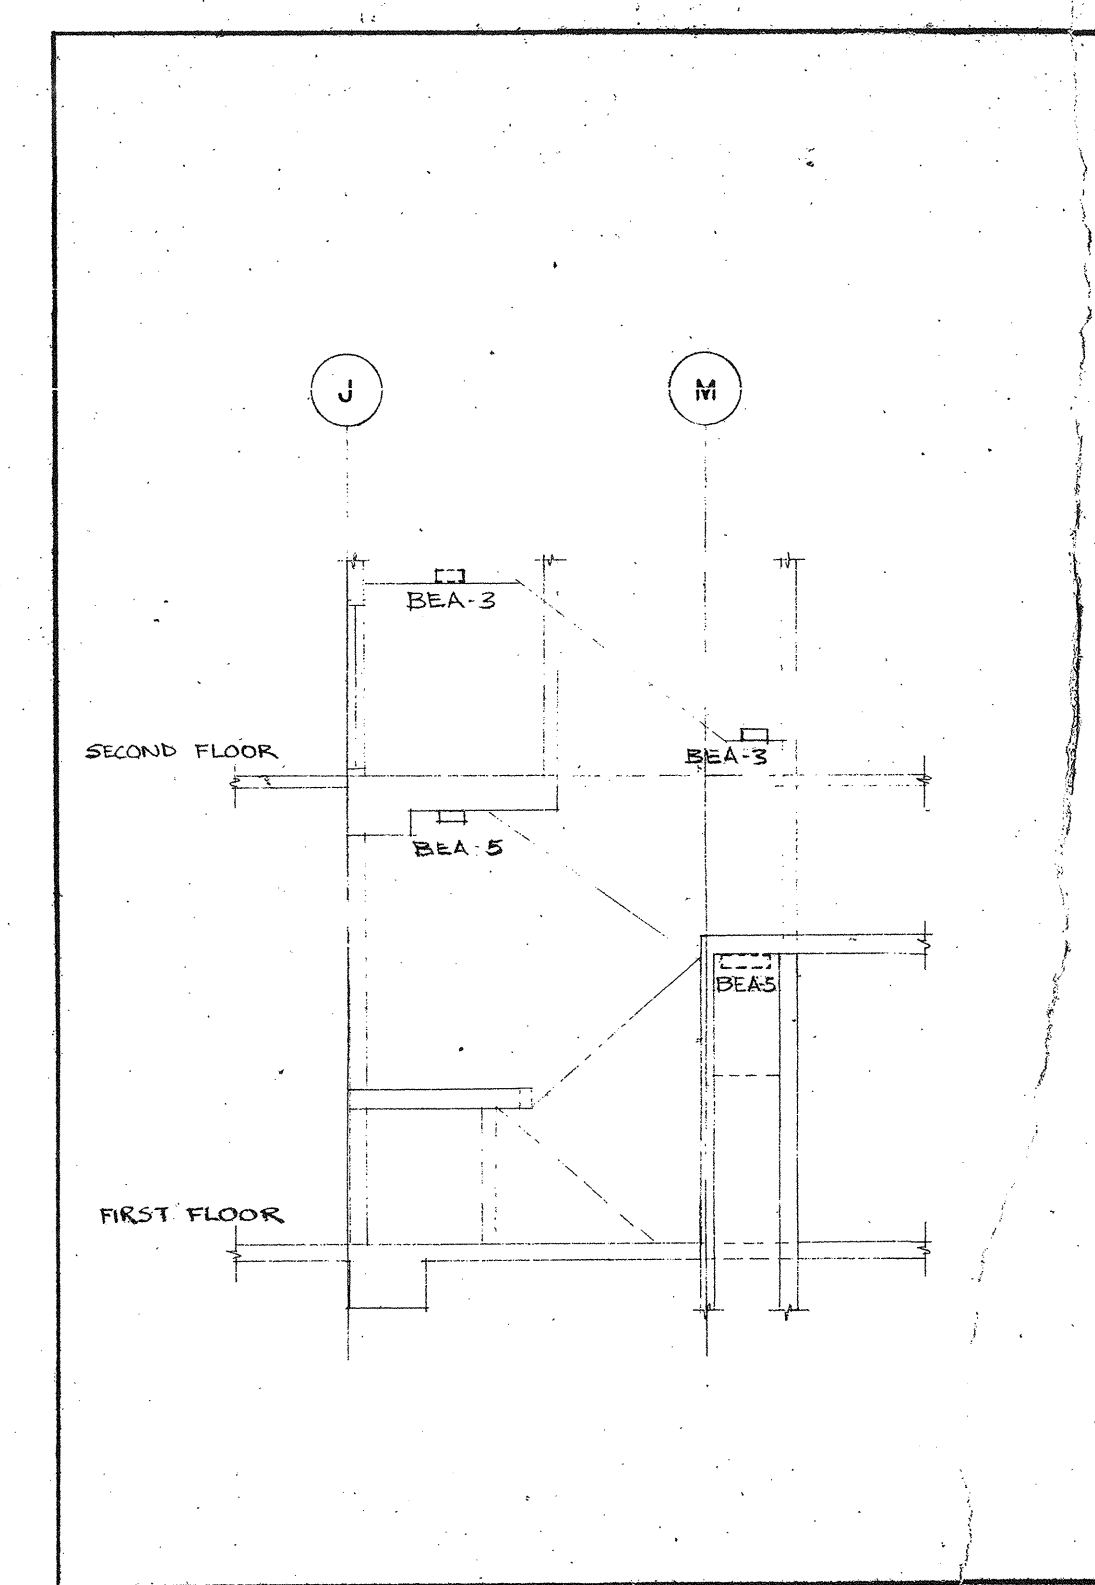

5 STAIR S5 LIGHTING RISER
SCALE: 1/8"=1'-0"

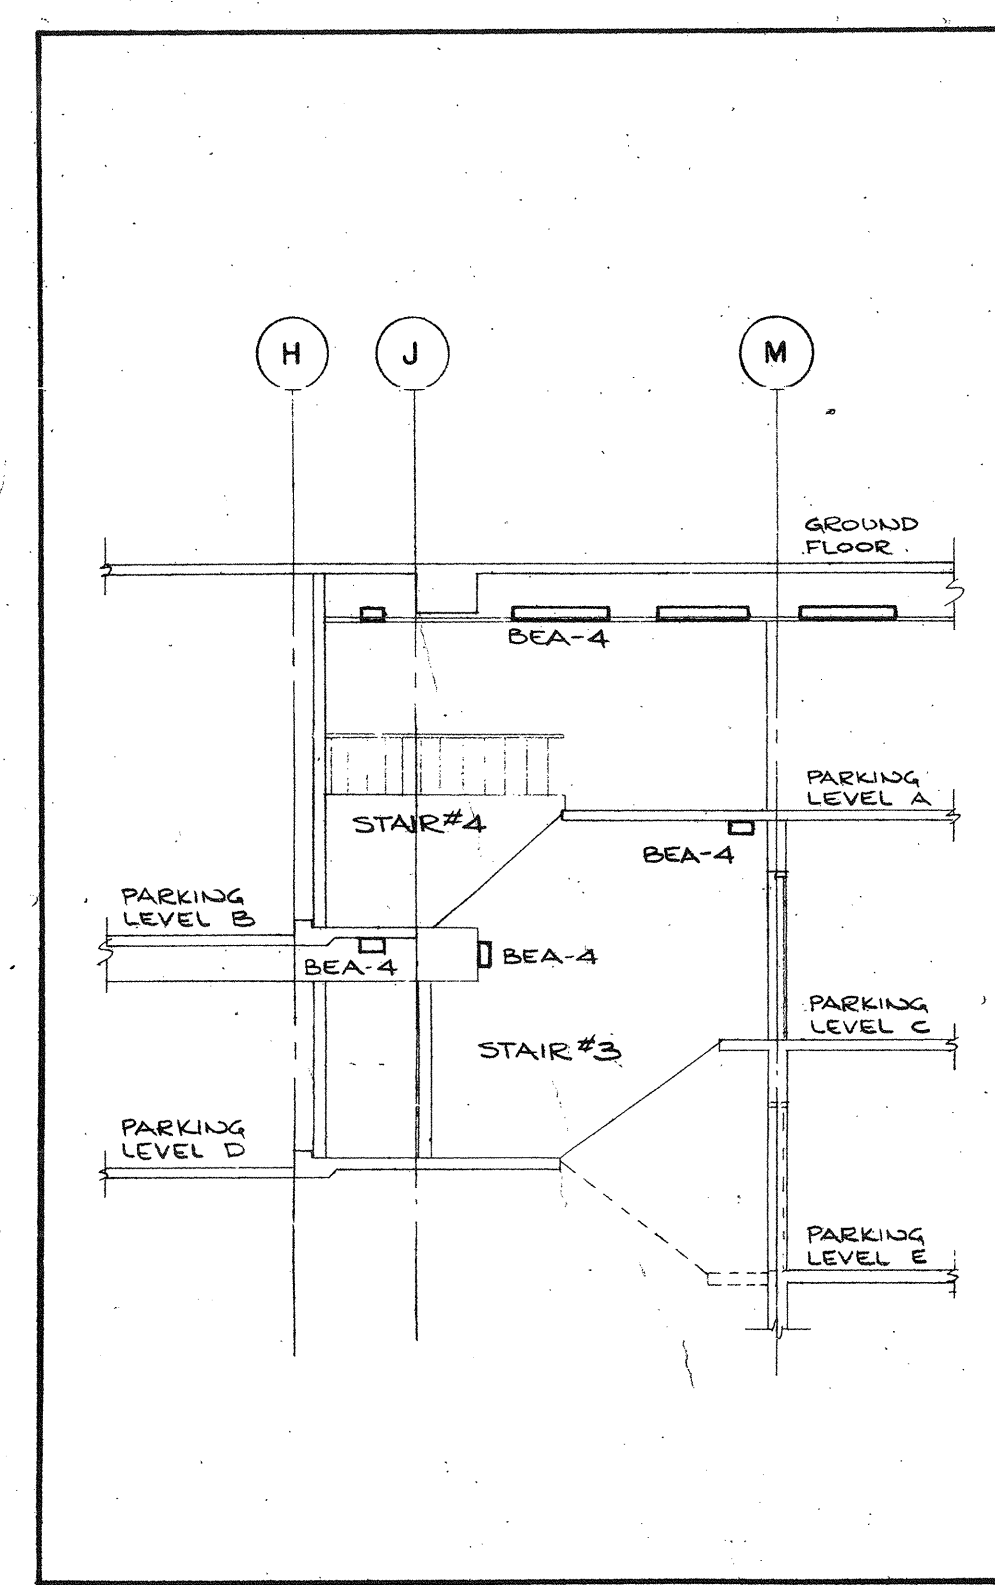


6 STAIRS S3 AND S4 LIGHTING RISER
SCALE: 1/8"=1'-0"

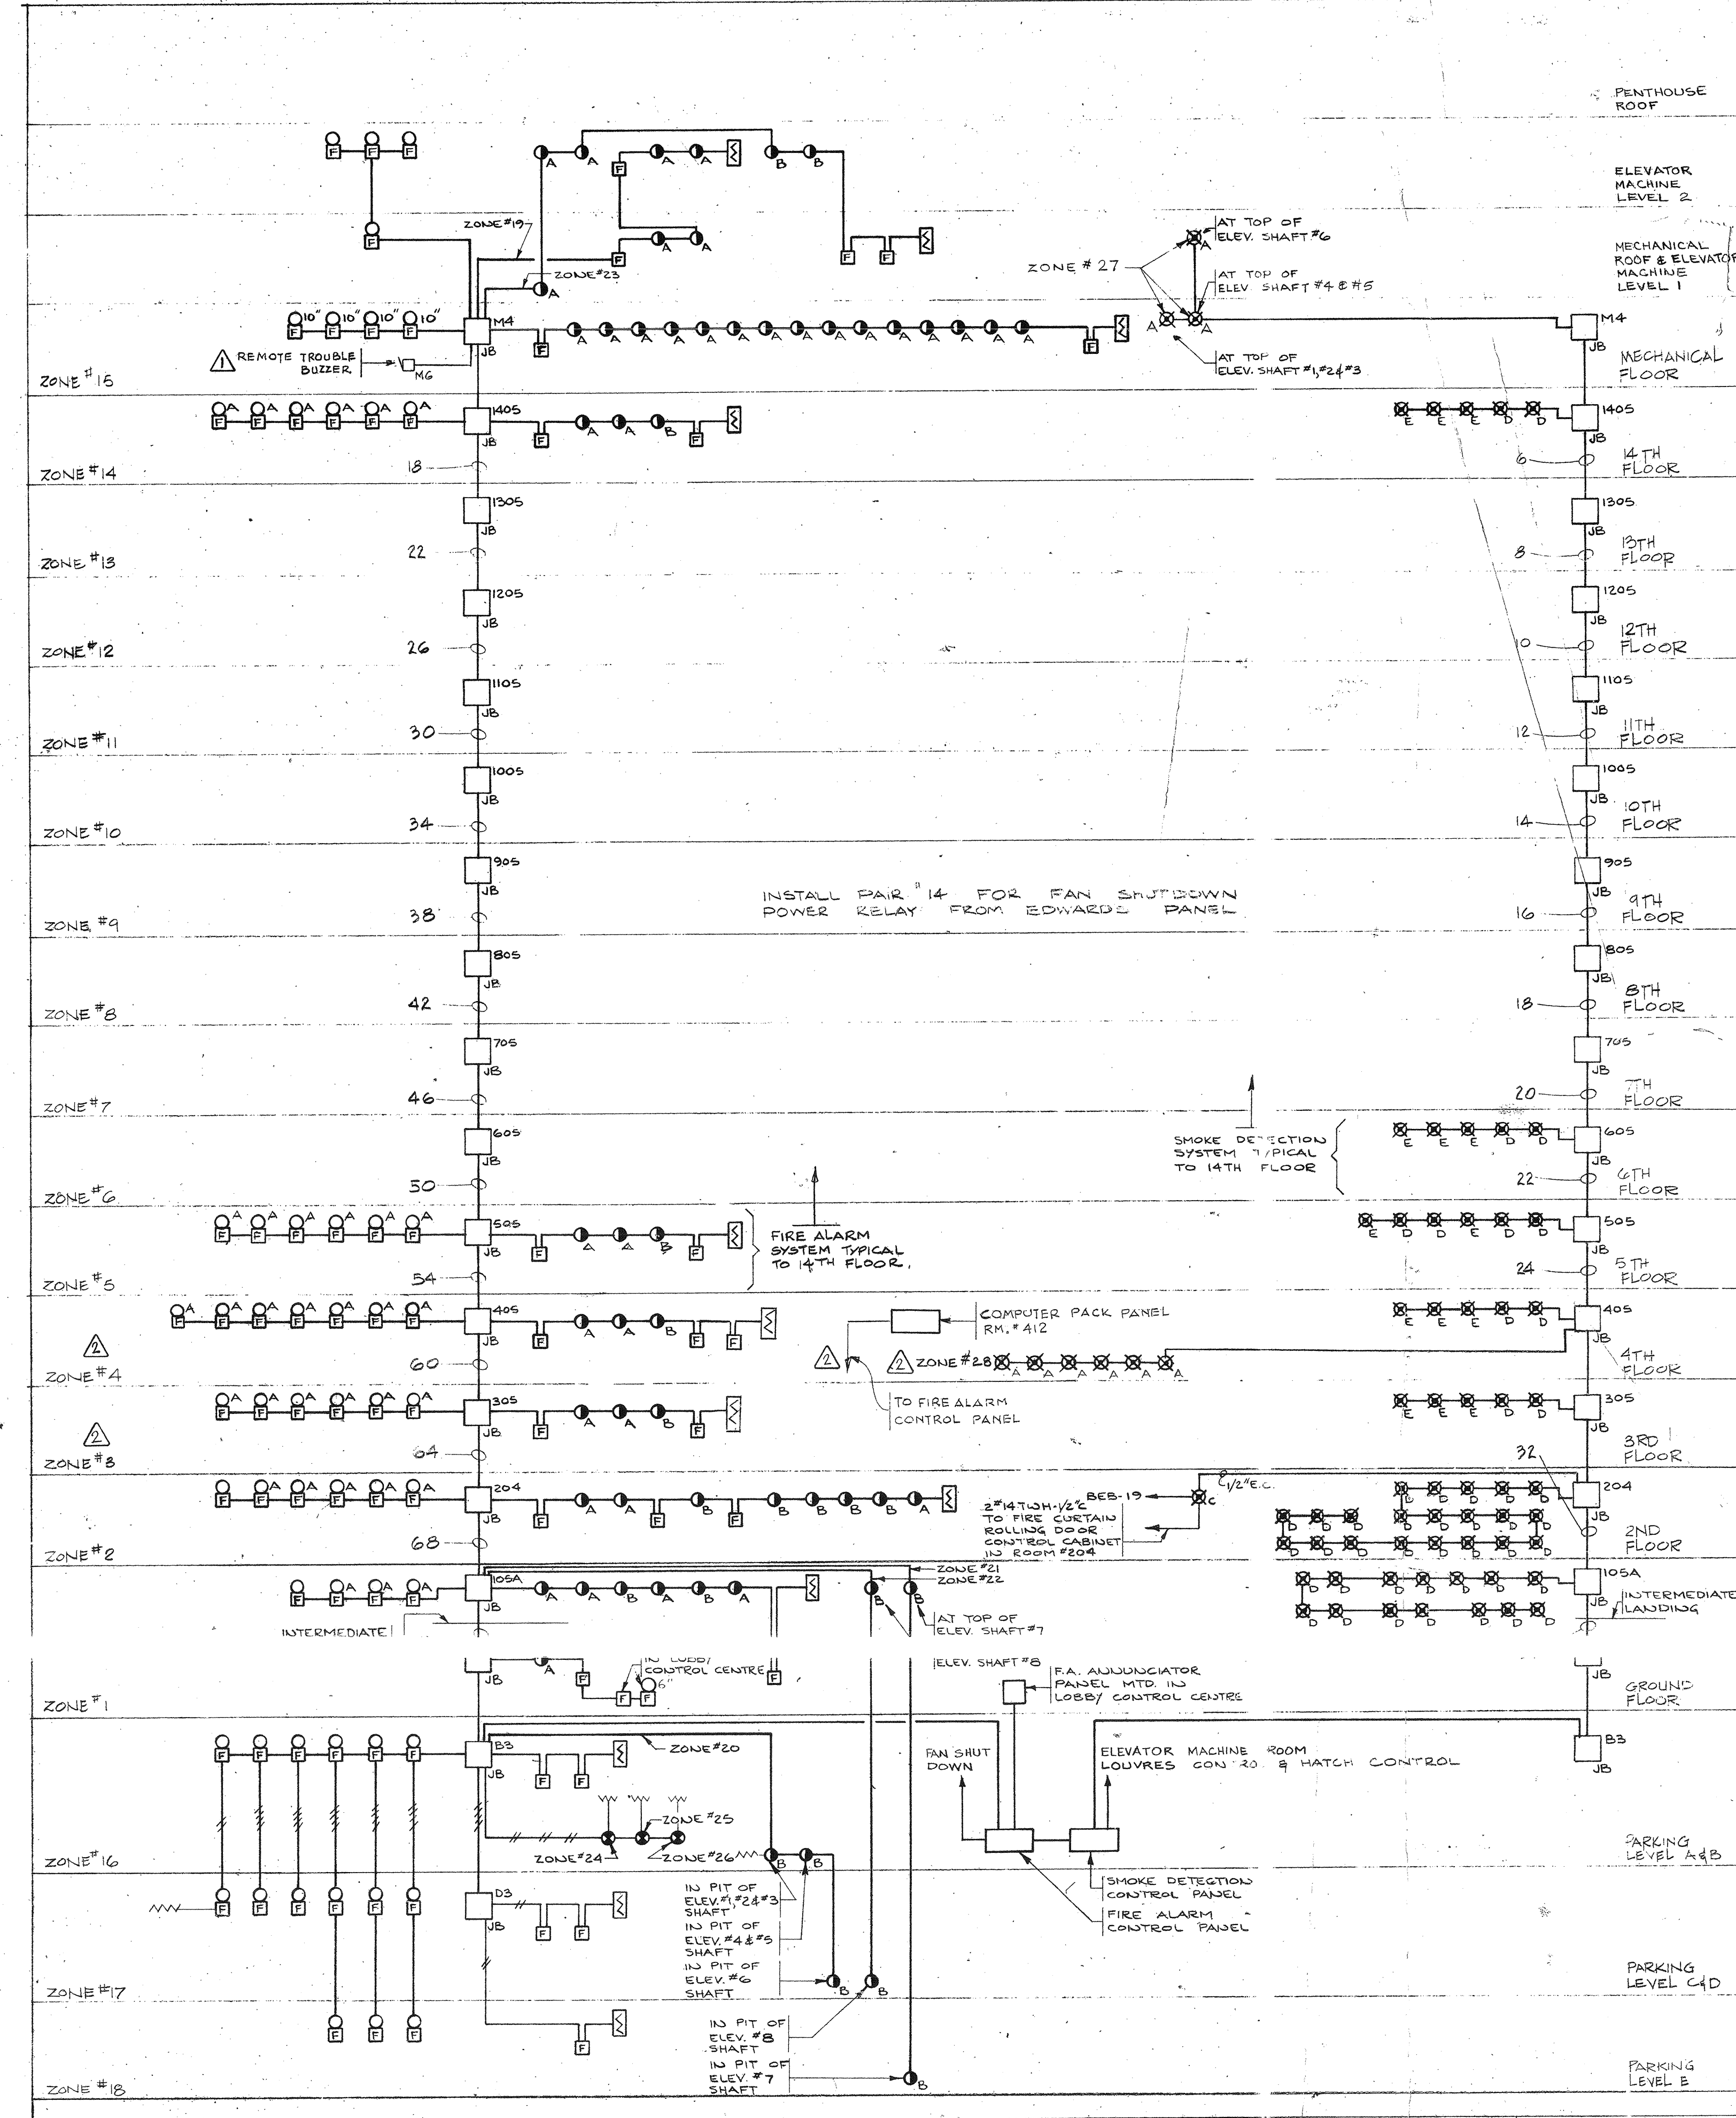


4 FIRE ALARM AND SMOKE DETECTION SYSTEMS RISER
N.T.S.

ZONE	DESCRIPTION
1	GROUND FLOOR
2	2ND FLOOR
3	3RD FLOOR
4	4TH FLOOR
5	5TH FLOOR
6	6TH FLOOR
7	7TH FLOOR
8	8TH FLOOR
9	9TH FLOOR
10	10TH FLOOR
11	11TH FLOOR
12	12TH FLOOR
13	13TH FLOOR
14	14TH FLOOR
15	MECHANICAL FLOOR
16	PARKING LEVEL A & B
17	PARKING LEVEL C & D
18	PARKING LEVEL E
19	ELEVATOR #1 TO #6 MACHINE ROOMS
20	ELEVATOR #7 TO #10
21	SHUTTLE ELEVATOR #11 (SHAFT & PIT)
22	FREIGHT ELEVATOR #12 (SHAFT & PIT)
23	PENTHOUSE FLOOR
24	SPRINKLER FLOW SWITCH
25	SPRINKLER FLOW SWITCH
26	SPRINKLER FLOW SWITCH
27	ELEVATOR SHAFTS - SMOKE
28	COMPUTER ROOM - SMOKE
29	COMPUTER ROOM - FIRE EXTINGUISHING SYSTEM ACTIVATED
30	SPARE
31	AIR DUCTS - SMOKE
32	SPARE
33	SPARE
34	SPARE
35	SPARE
36	SPARE


7 FIRE ALARM ZONE SCHEDULE
N.T.S.

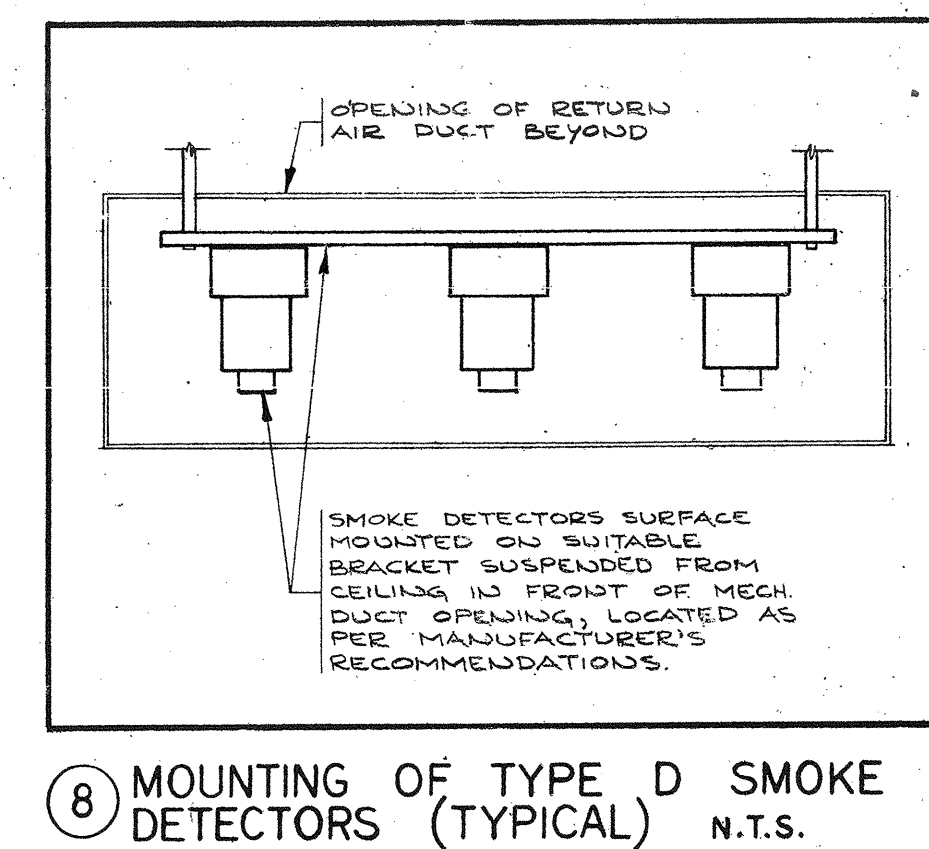

8 MOUNTING OF TYPE D SMOKE DETECTORS (TYPICAL)
N.T.S.

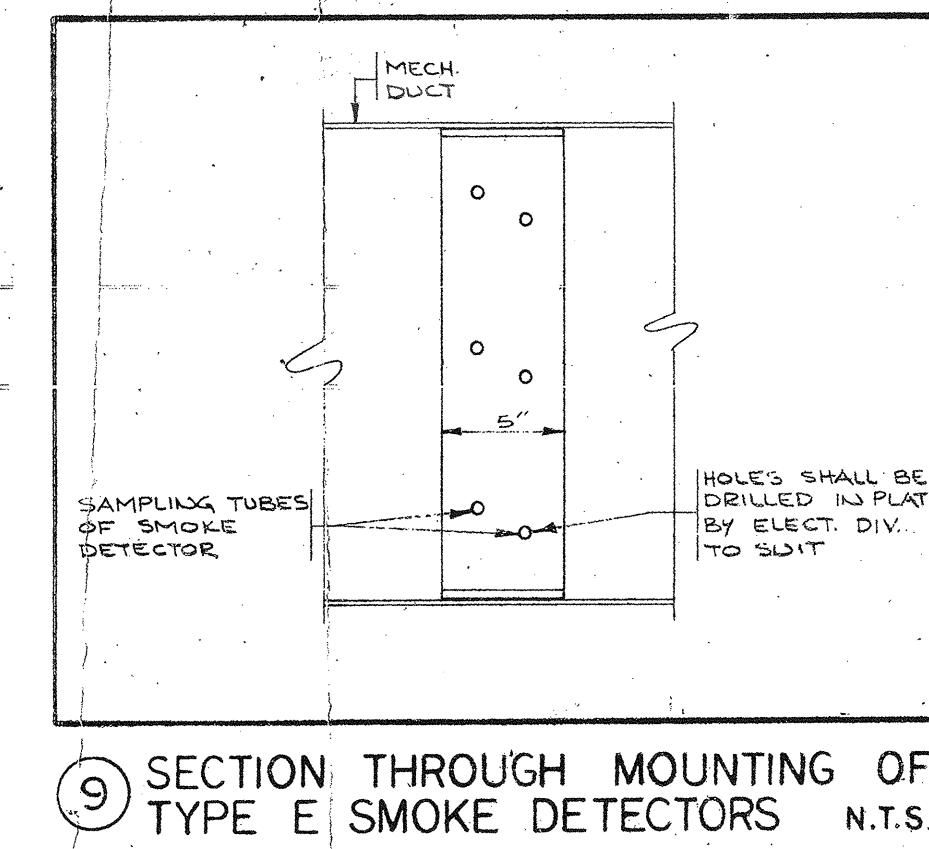

9 SECTION THROUGH MOUNTING OF TYPE E SMOKE DETECTORS (TYPICAL)
N.T.S.

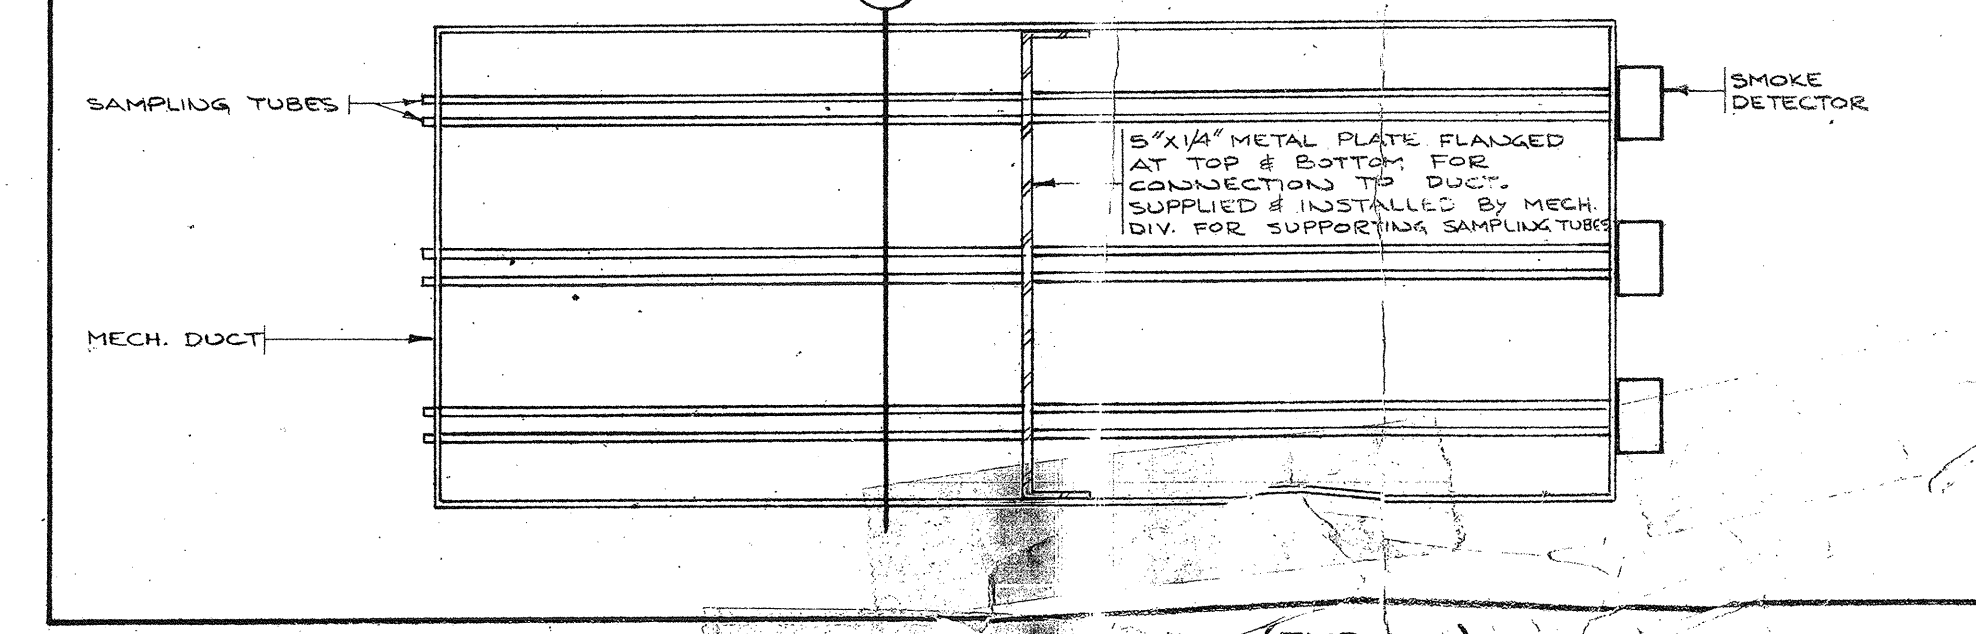

10 MOUNTING OF TYPE E SMOKE DETECTOR (TYPICAL)
N.T.S.

No.	Ref.	Description	Date	Ch'd
2	Δ	ΔC0 10-2-7	ΔC0	ΔC0
3	Δ	REVISION FOR COT 10-2-7	10-2-7	ΔC0
4	Δ	REVISION FOR COT 3-5	3-5	ΔC0
5		REV FOR CONSTRUCTION	2-20-77	ΔC0
6	1	REVISION FOR COT 10-2-7	10-2-7	ΔC0
7		REVISION FOR COT 10-2-7	10-2-7	ΔC0

No.	Ref.	Description	Date	Ch'd
Revisions				
Drawn M.L.D. M.P. 1 G.M. Date 5 FEB. 1971 Checked C.A. <i>[Signature]</i> Pre-Design Design P.J. Architectural A.R. Structural B.U. Heating A.L. Sanitary A.L. Electrical C.A. Specifications K.K. Process Printer				

NORTH

→

ENGINEER
 MEMBERS
 1971