




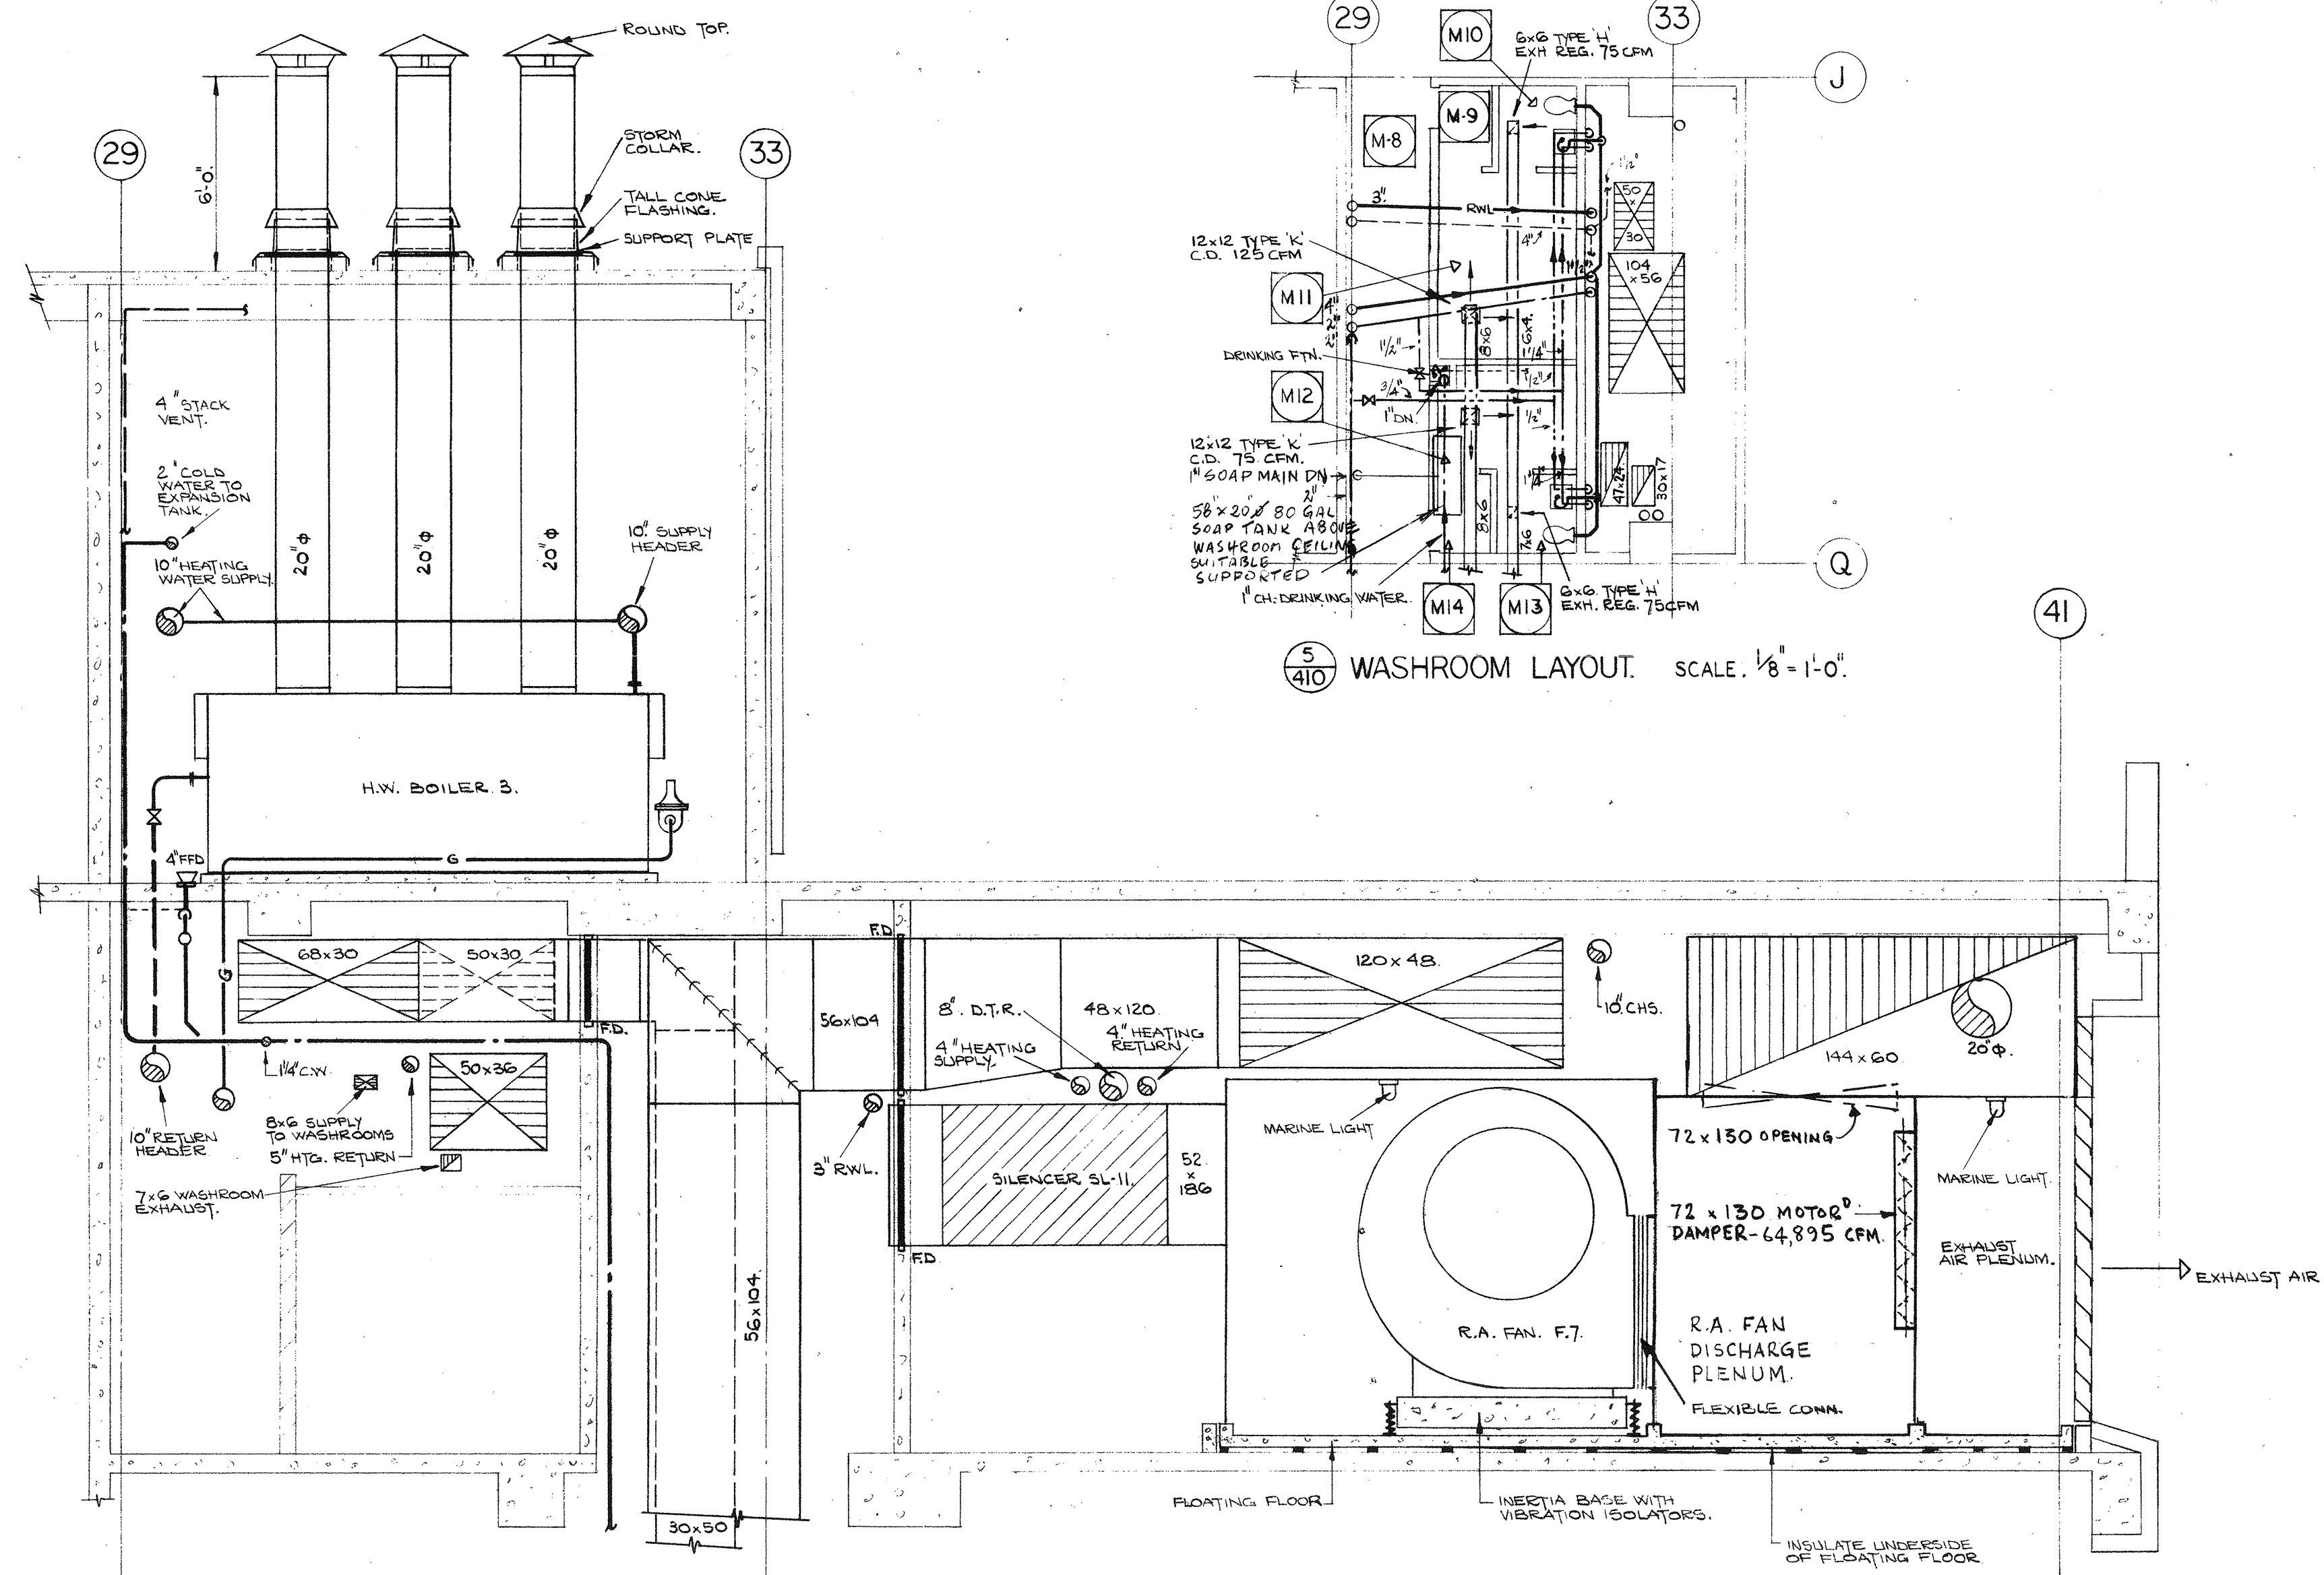


1 SECTION. SCALE: 1/4"=1'-0"

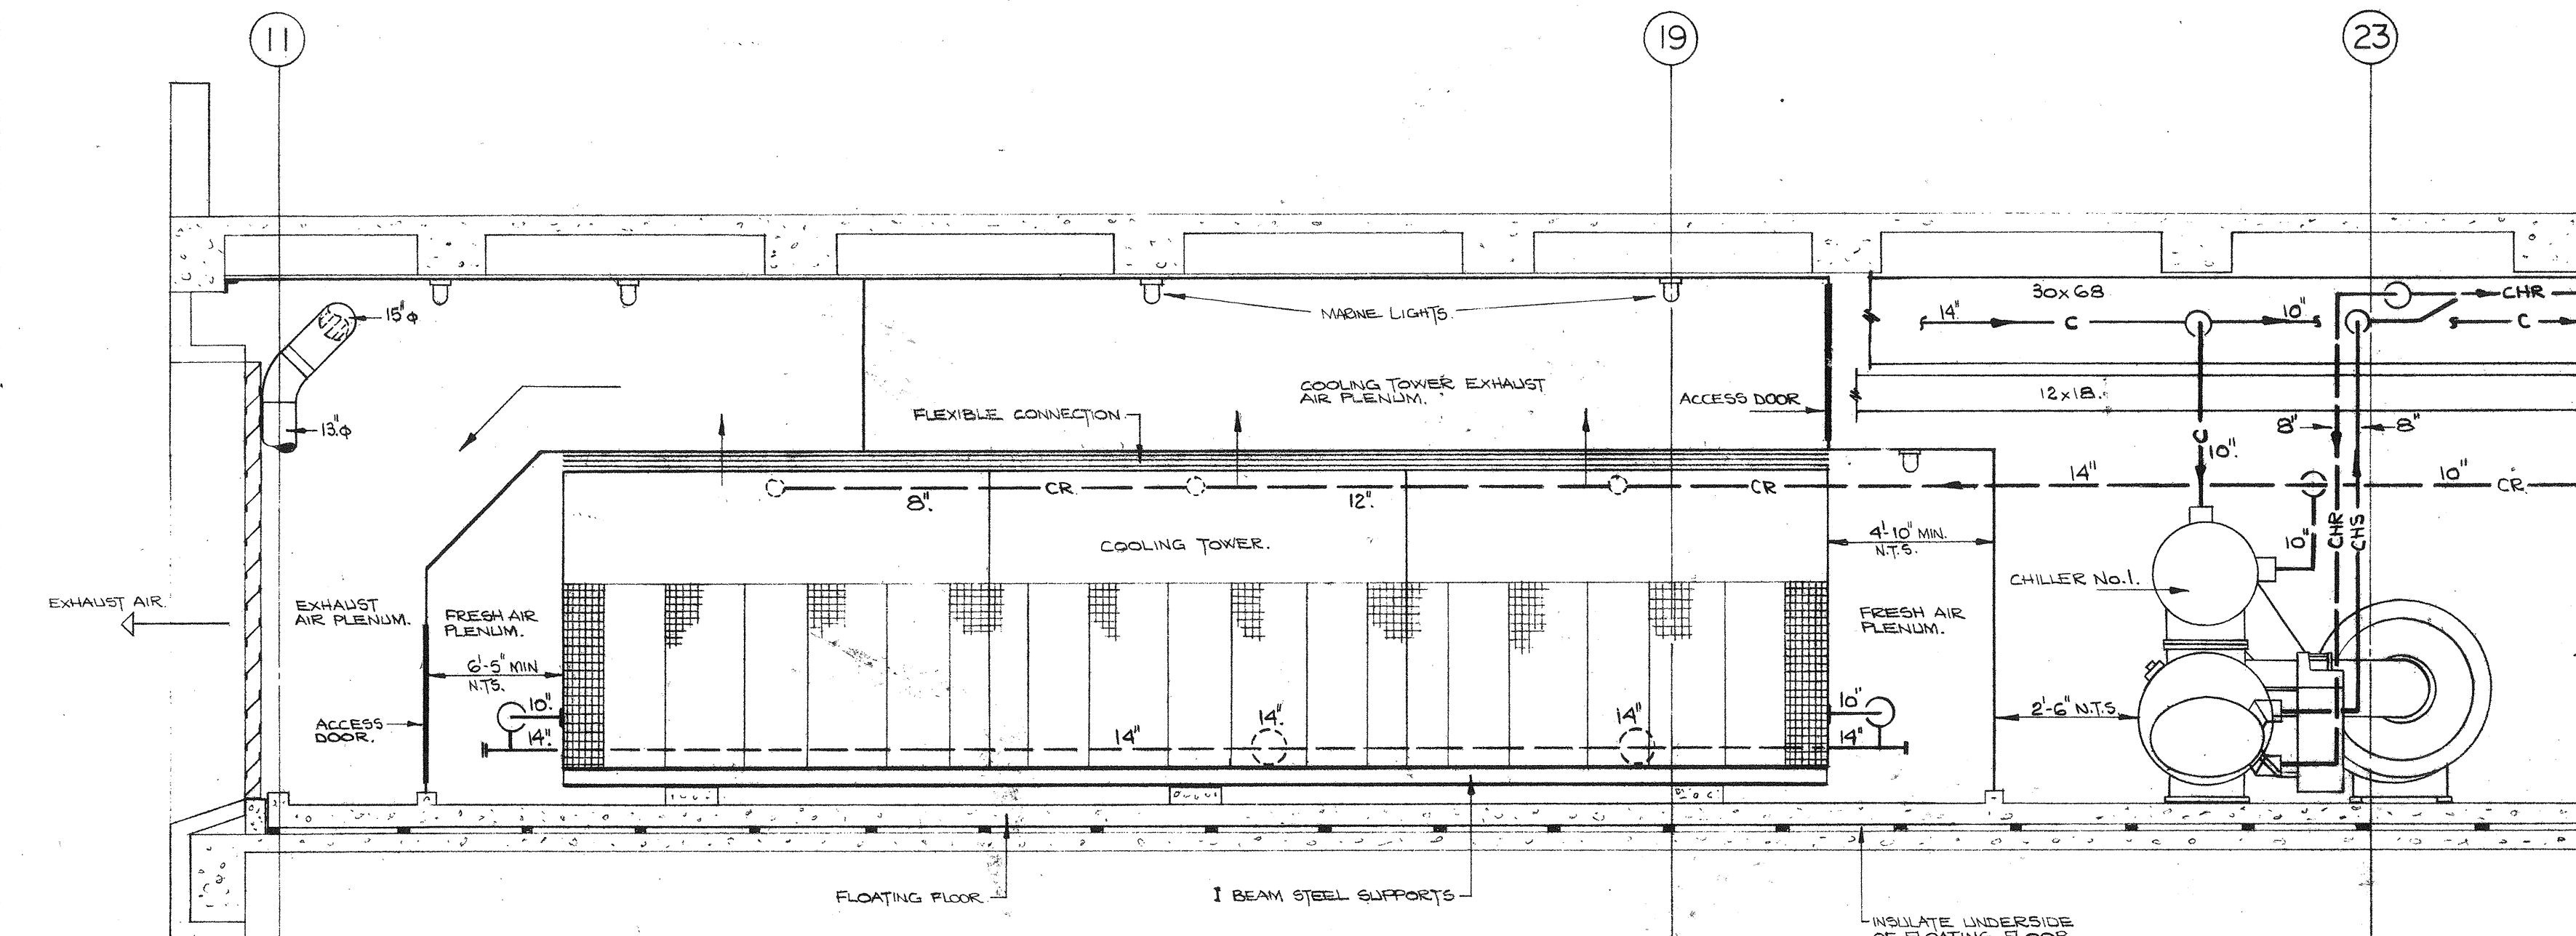


2 SECTION. SCALE: 1/4"=1'-0"

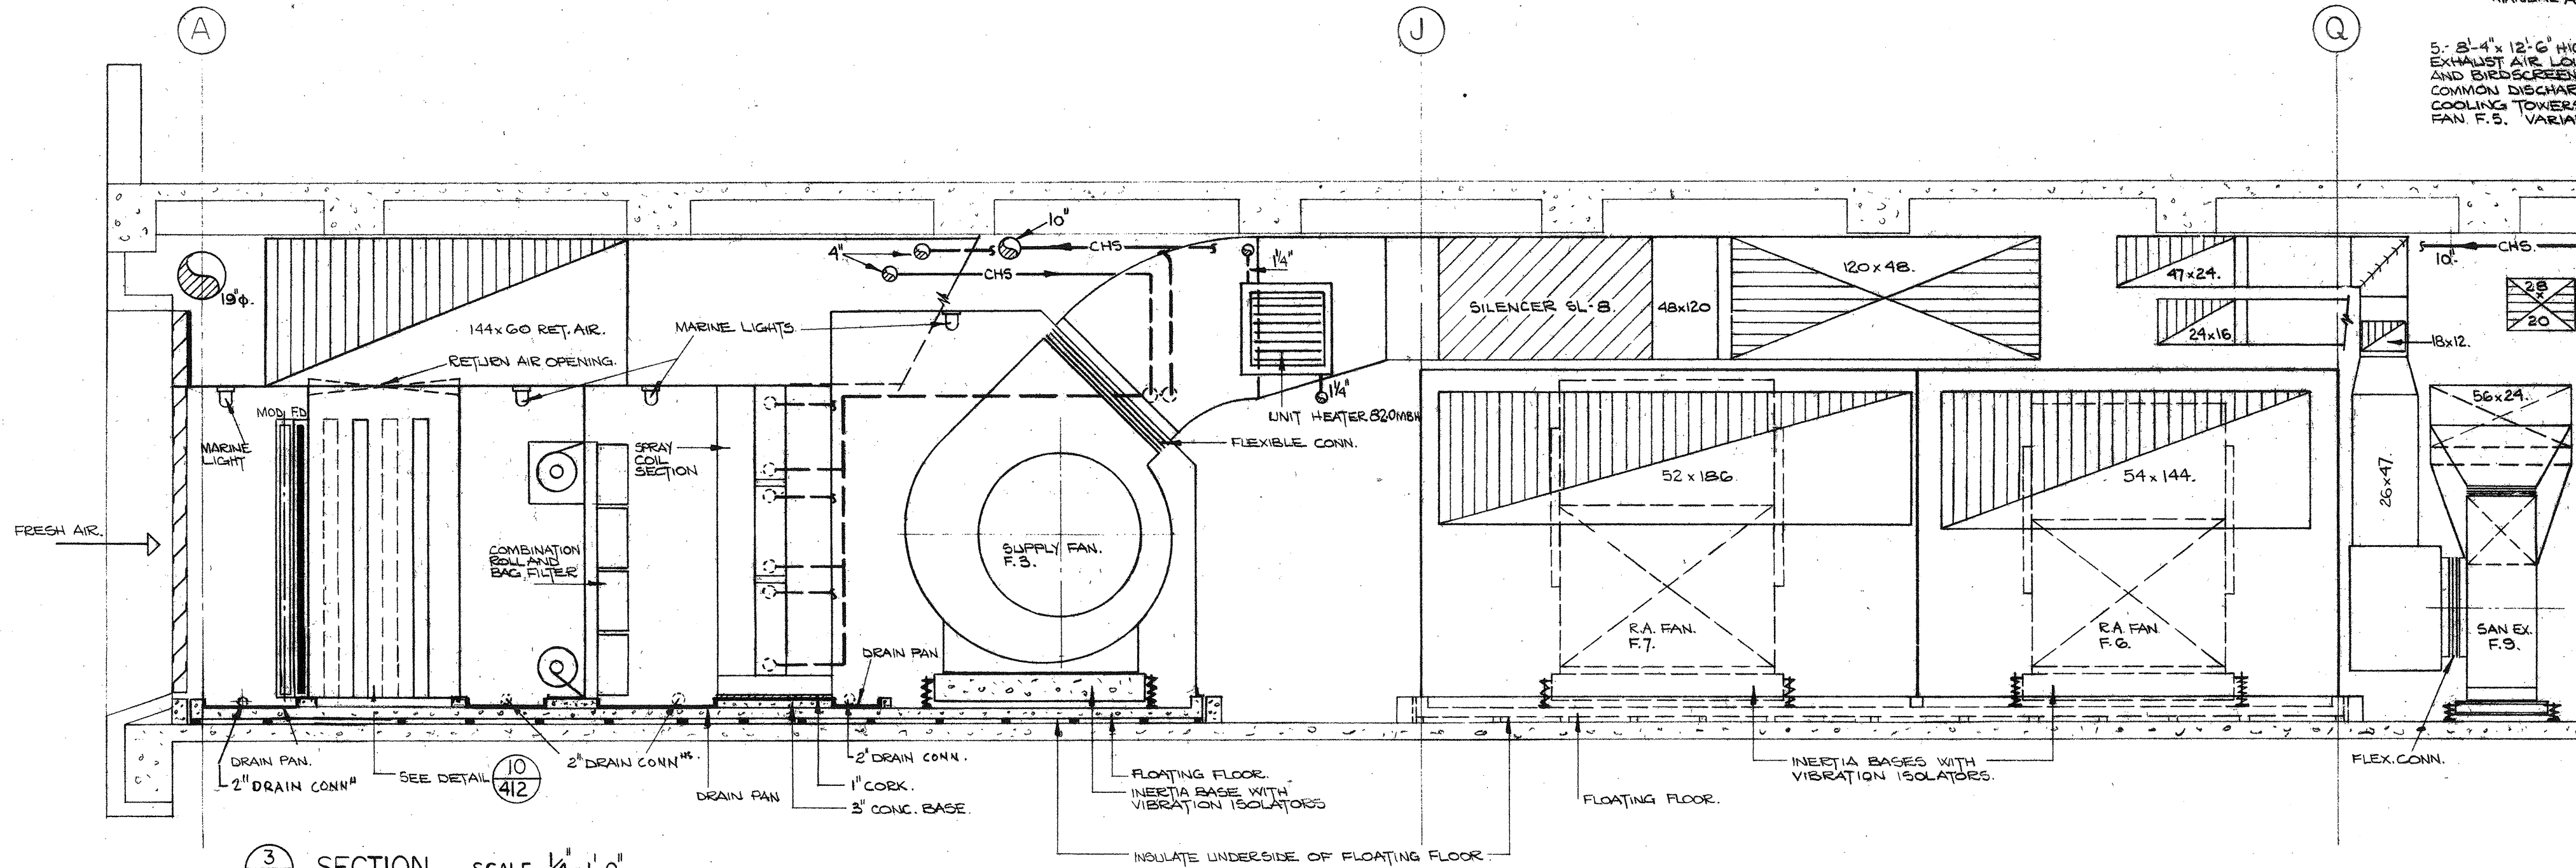


3 SECTION. SCALE: 1/4"=1'-0"

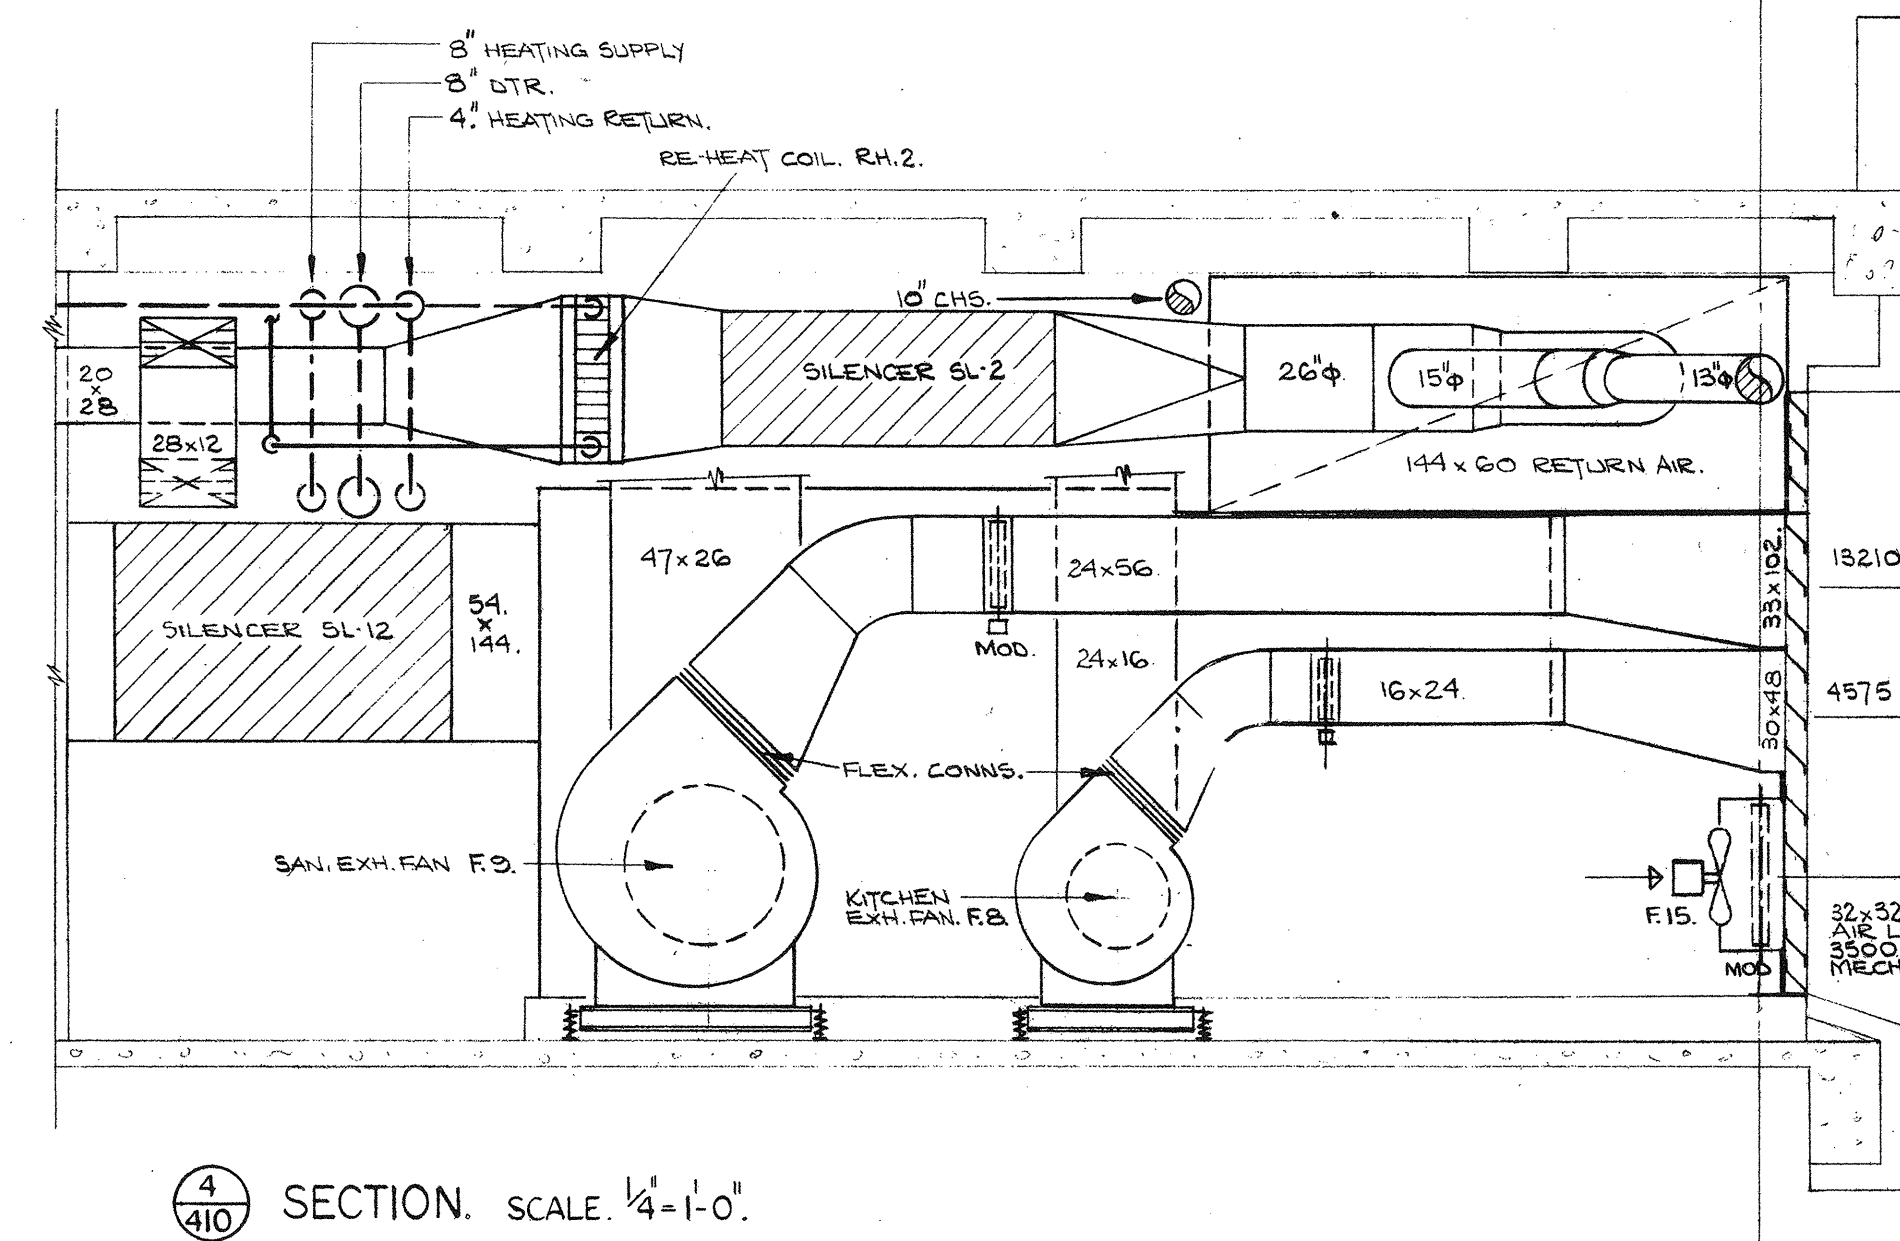

4 SECTION. SCALE: 1/4"=1'-0"

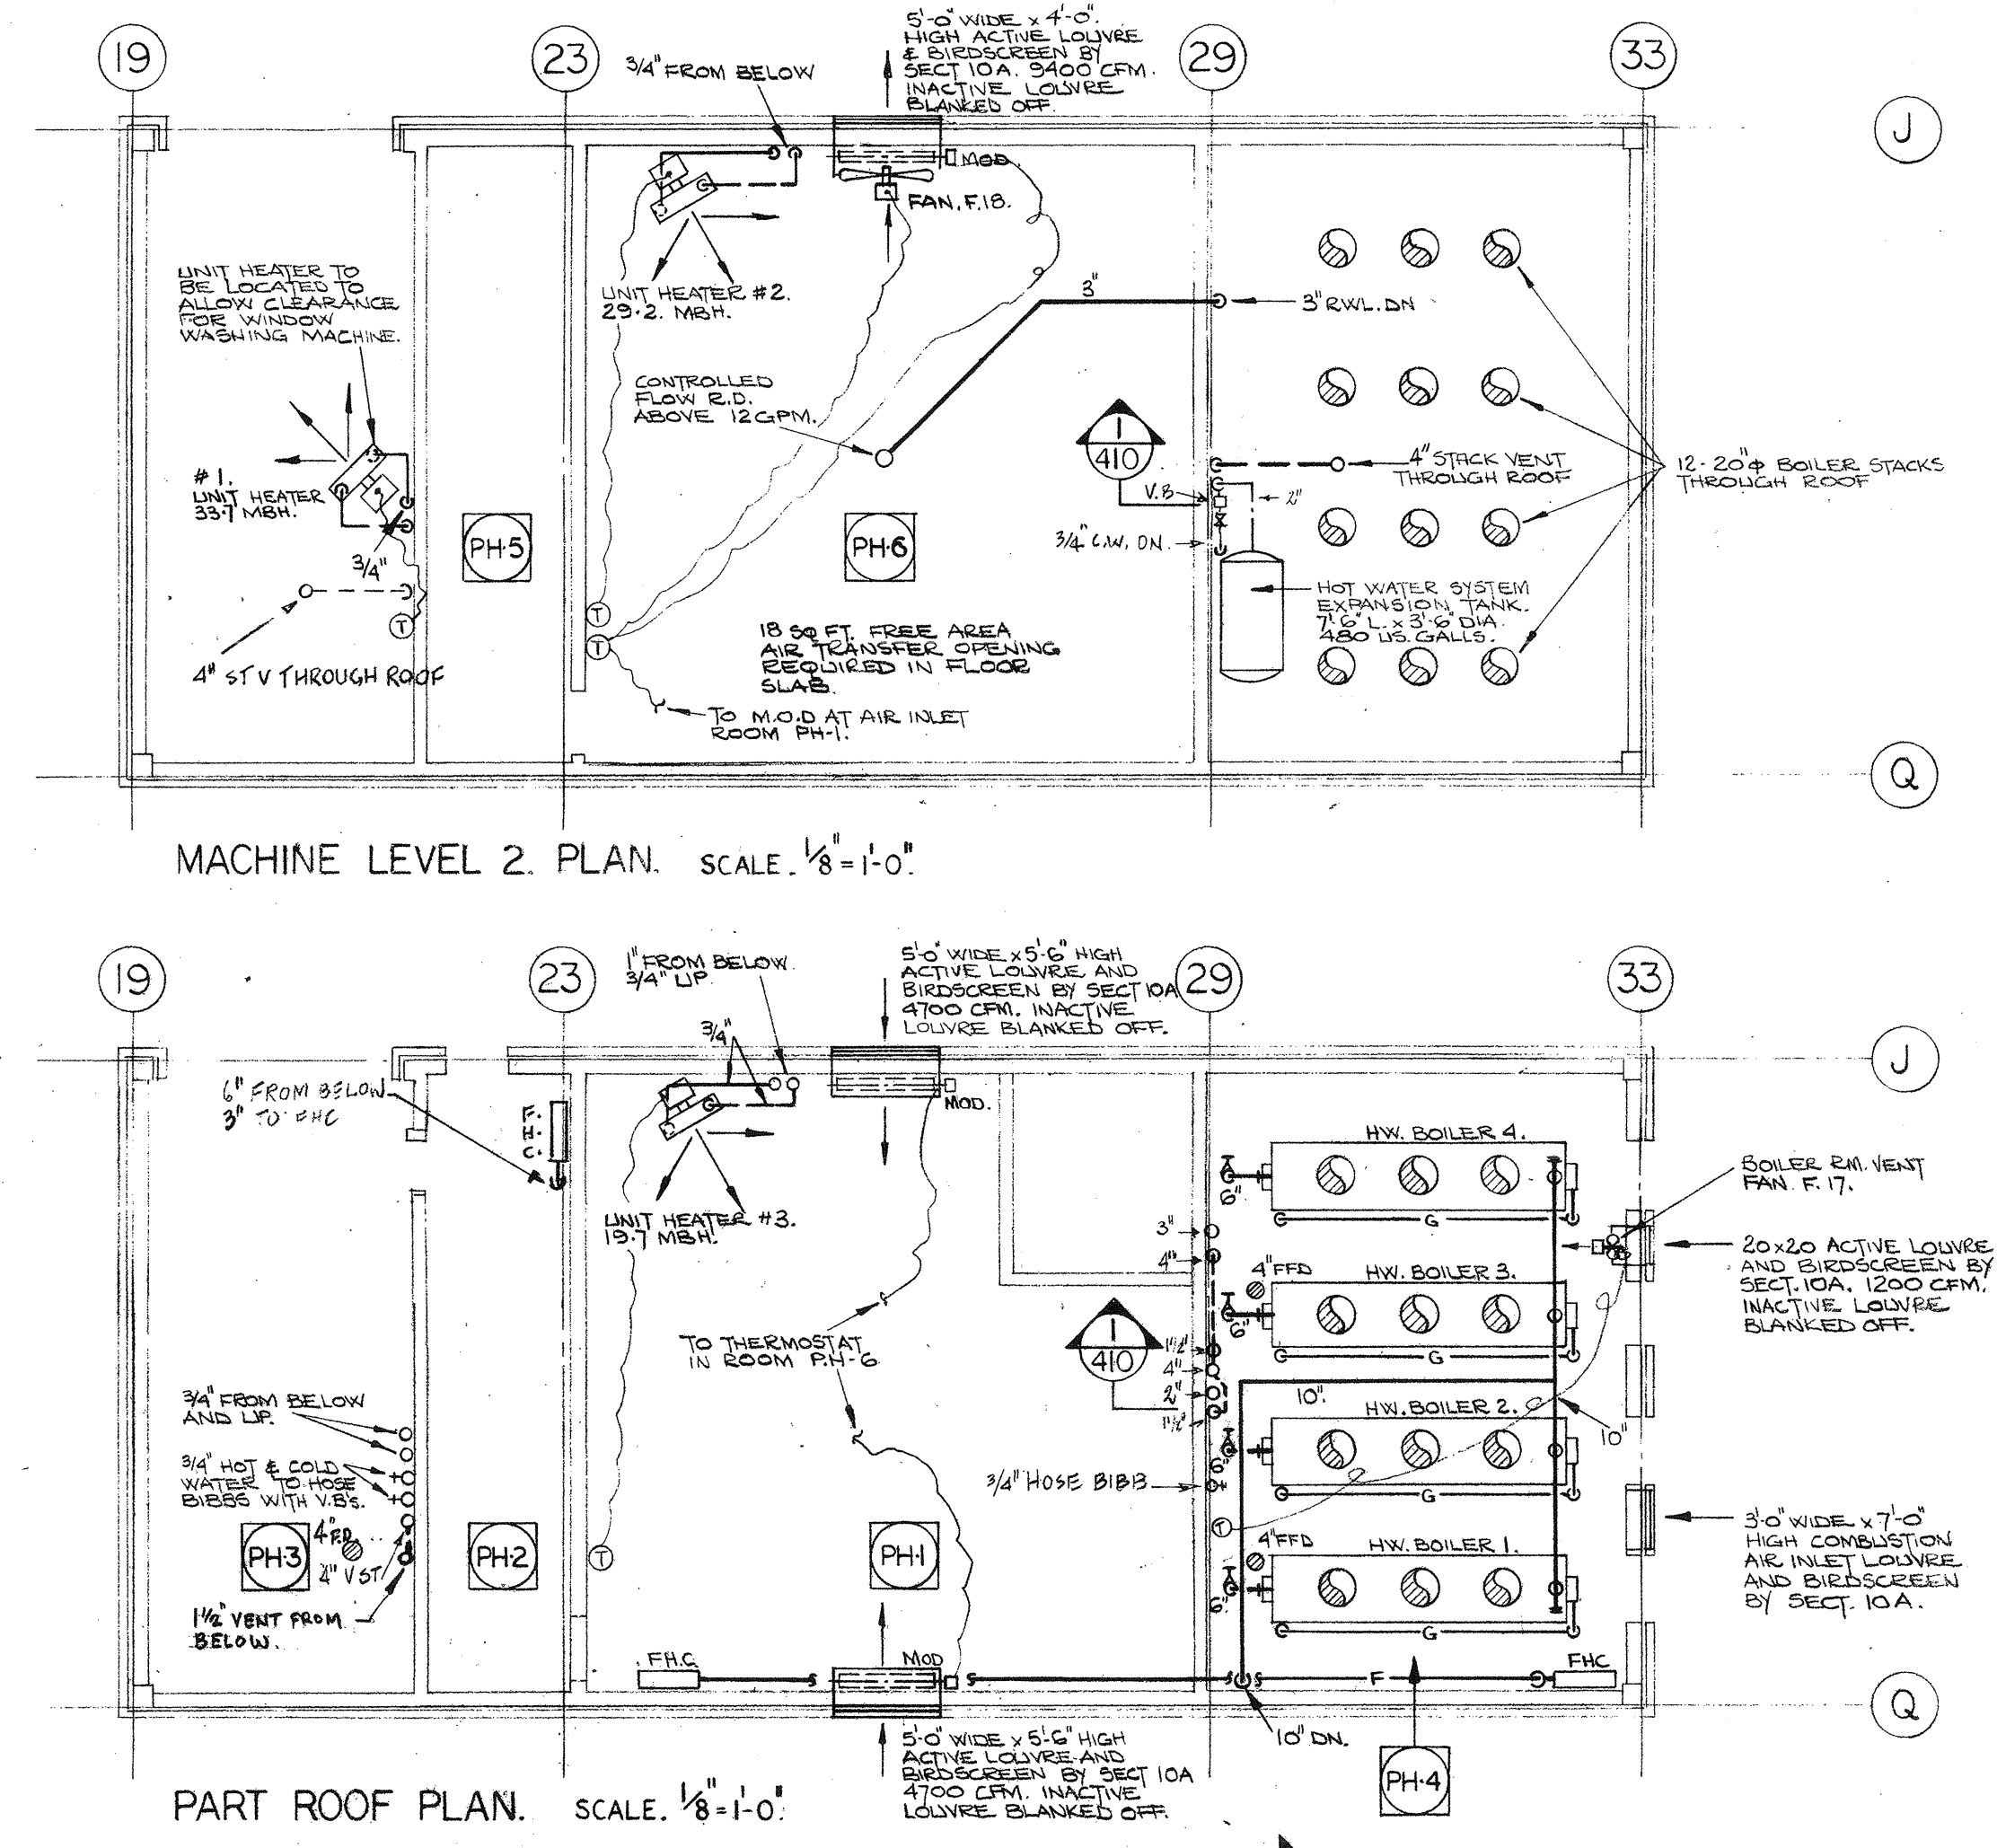

PART ROOF PLAN. SCALE: 1/8"=1'-0"

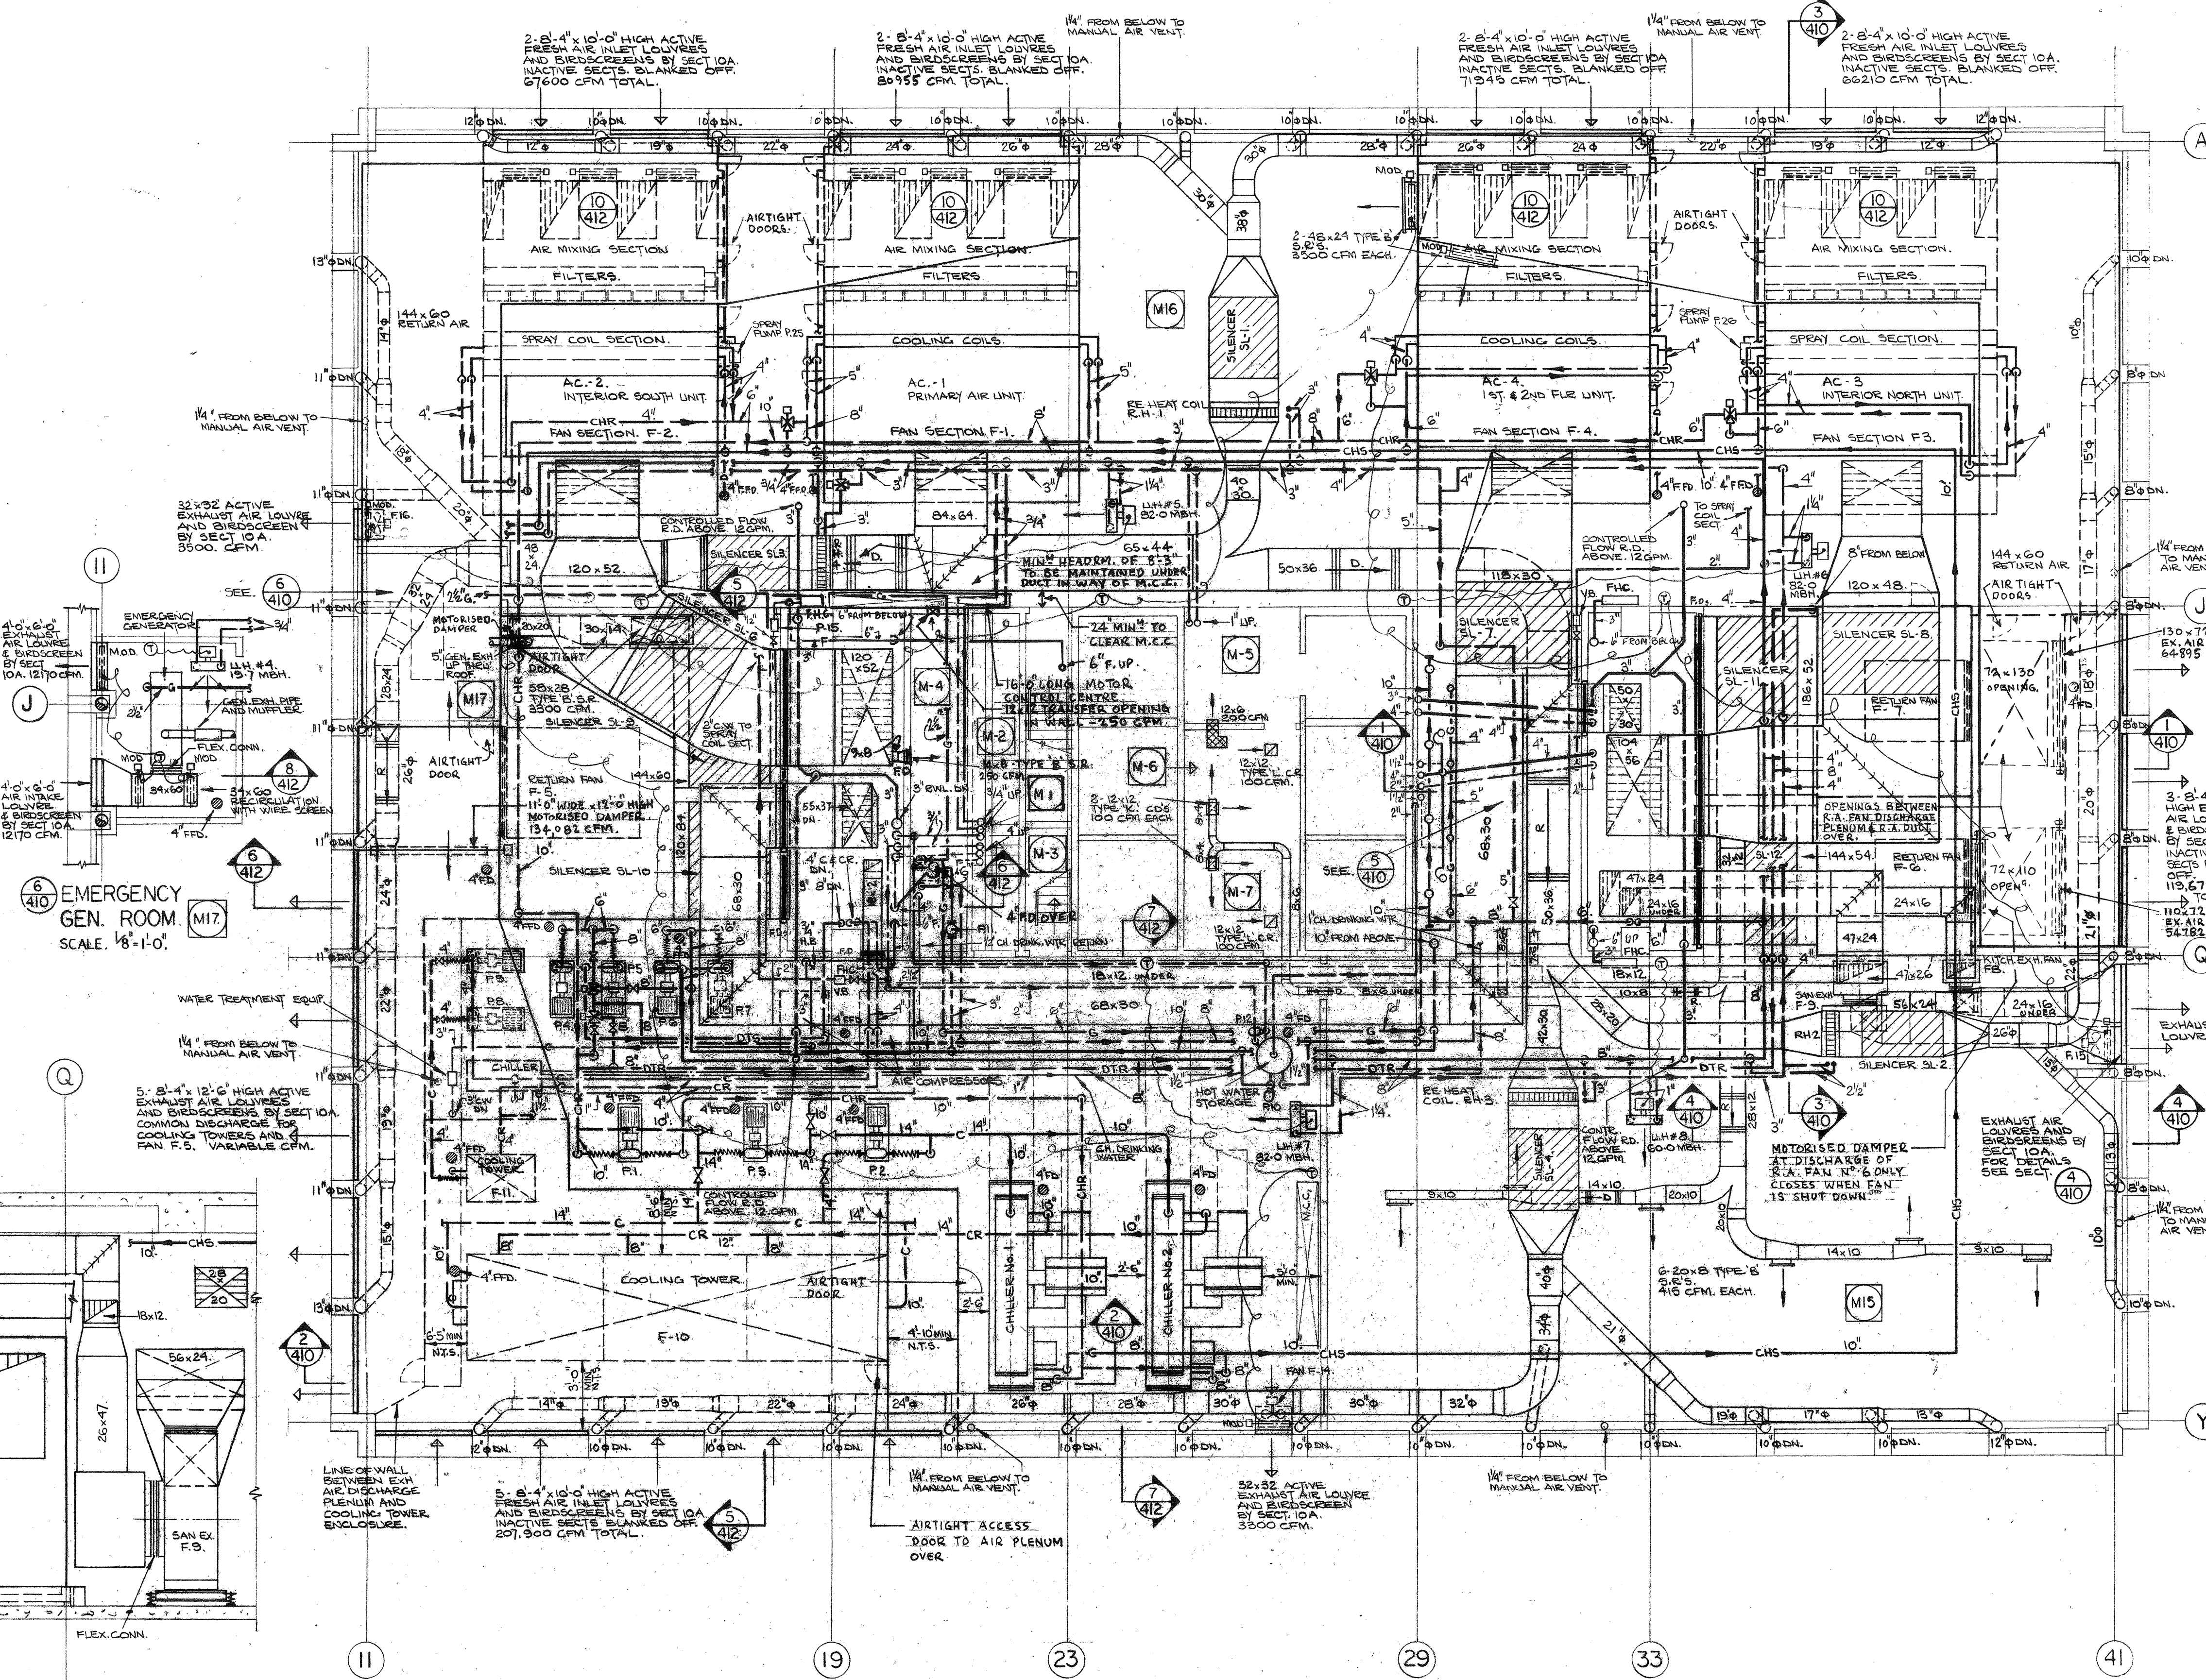

MECHANICAL FLOOR PLAN. SCALE: 1/8"=1'-0"

No.	Ref.	Description	Date	Chd
1		Revisions		
2		Drawn by		
3		Checked by		
4		Design by		
5		Structural by		
6		Sanitary by		
7		Electrical by		
8		Specifications by		
9		Process		
10		Printed		

All measurements must be checked on the work by the contractor.
All prints and specifications are the property of the architect and must be returned at the completion of the work.
This drawing not to be used for construction purposes until countersigned by:
Date

NATIONAL LIFE OF CANADA
Head Office Building
University Avenue, Toronto, Canada

Parkin Searle Wilbee Rowland
Architects
Engineers
Planners

AIR CONDITIONING & PLUMBING MECHANICAL FLOOR & PENTHOUSES
Sheet Title
Scale: 1/8"=1'-0" & 1/4"=1'-0"
Sheet Number: 69039-410